


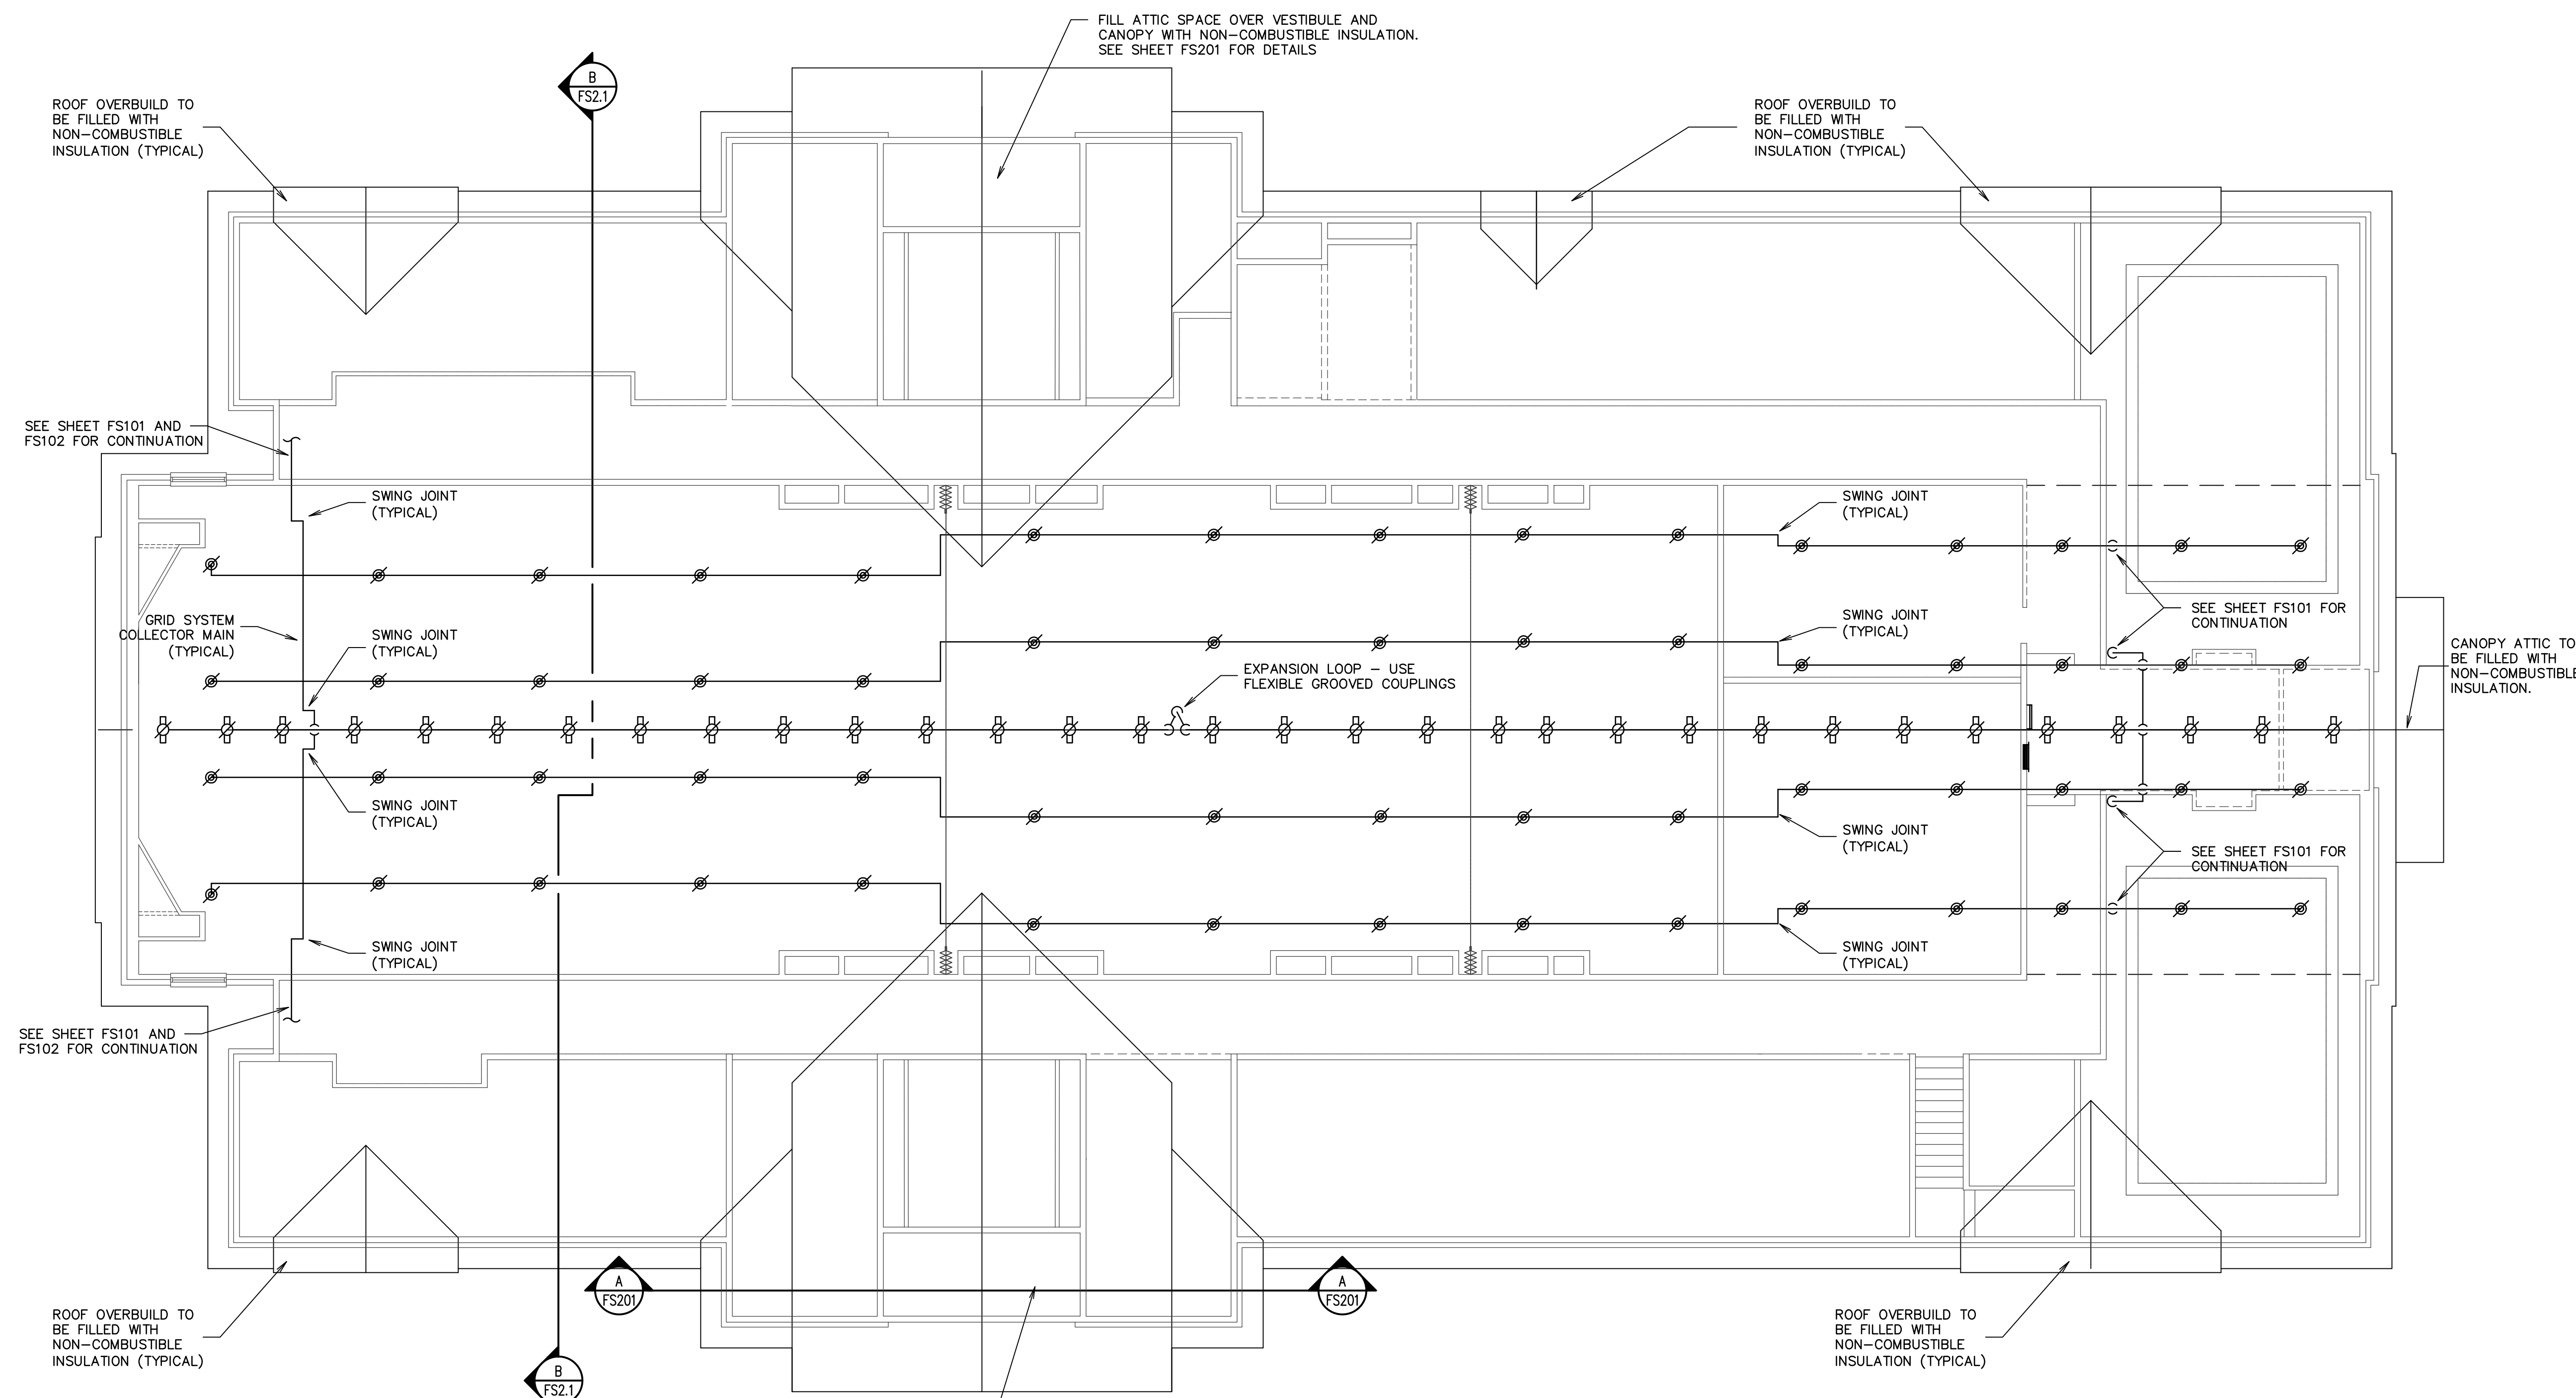

UPPER LEVEL, CHAPEL AND CULTURAL CENTER
FIRE SPRINKLER PLAN

1/8" = 1'-0"

SEE NOTES - SHEET FS101



Architect / Engineer:
nbwarchitects p.a.
ARCHITECTURAL PLANNING / INTERIORS
SCOTT NELSON AIA, KEVIN R. BOOBY AIA, JAMES H. WYATT AIA,
900 JOHN BOHNS PARKWAY, P.O. BOX 2217 - IDAHO FALLS, IDAHO 83402-2212
(208) 322-8775 (208) 322-8783 (0) www.nbwarchitects.com

Stamp:

Billings Sweet Grass Creek
Heritage 98
Billings Montana Stake
2620 54th Street W.
Billings Montana 59106

Project for:
**THE CHURCH OF
JESUS CHRIST
OF LATTER-DAY SAINTS**


Rev	Date	Description

Project Number:
15047
Plan Series:
HER-TRA-98-20
Property Number:
501-1850

Sheet Title:
**UPPER LEVEL
CHAPEL AND
CULTURAL
CENTER FIRE
SPRINKLER
PLAN**

Sheet:
FS103

ORIGINAL DRAWING SIGNED BY: DWAYNE C. SUDWEEKS
DATE ORIGINAL SIGNED: Sep 07, 2016
ORIGINAL ON FILE AT ENGINEERED SYSTEMS ASSOCIATES
1355 EAST CENTER, POCATELLO, IDAHO 83201

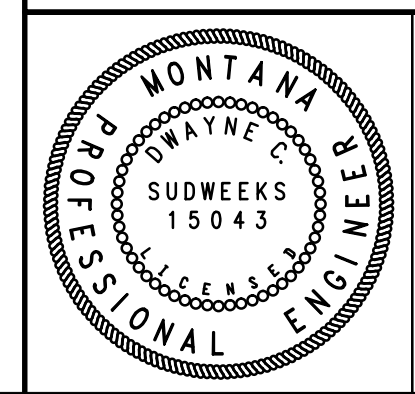

**Engineered
Systems
Associates**
1355 EAST CENTER
POCATELLO, IDAHO 83201
PHONE: (208) 233-0501
FAX: (208) 233-0529
EMAIL: esa@engsystems.com
ESA JOB NUMBER: 15001