
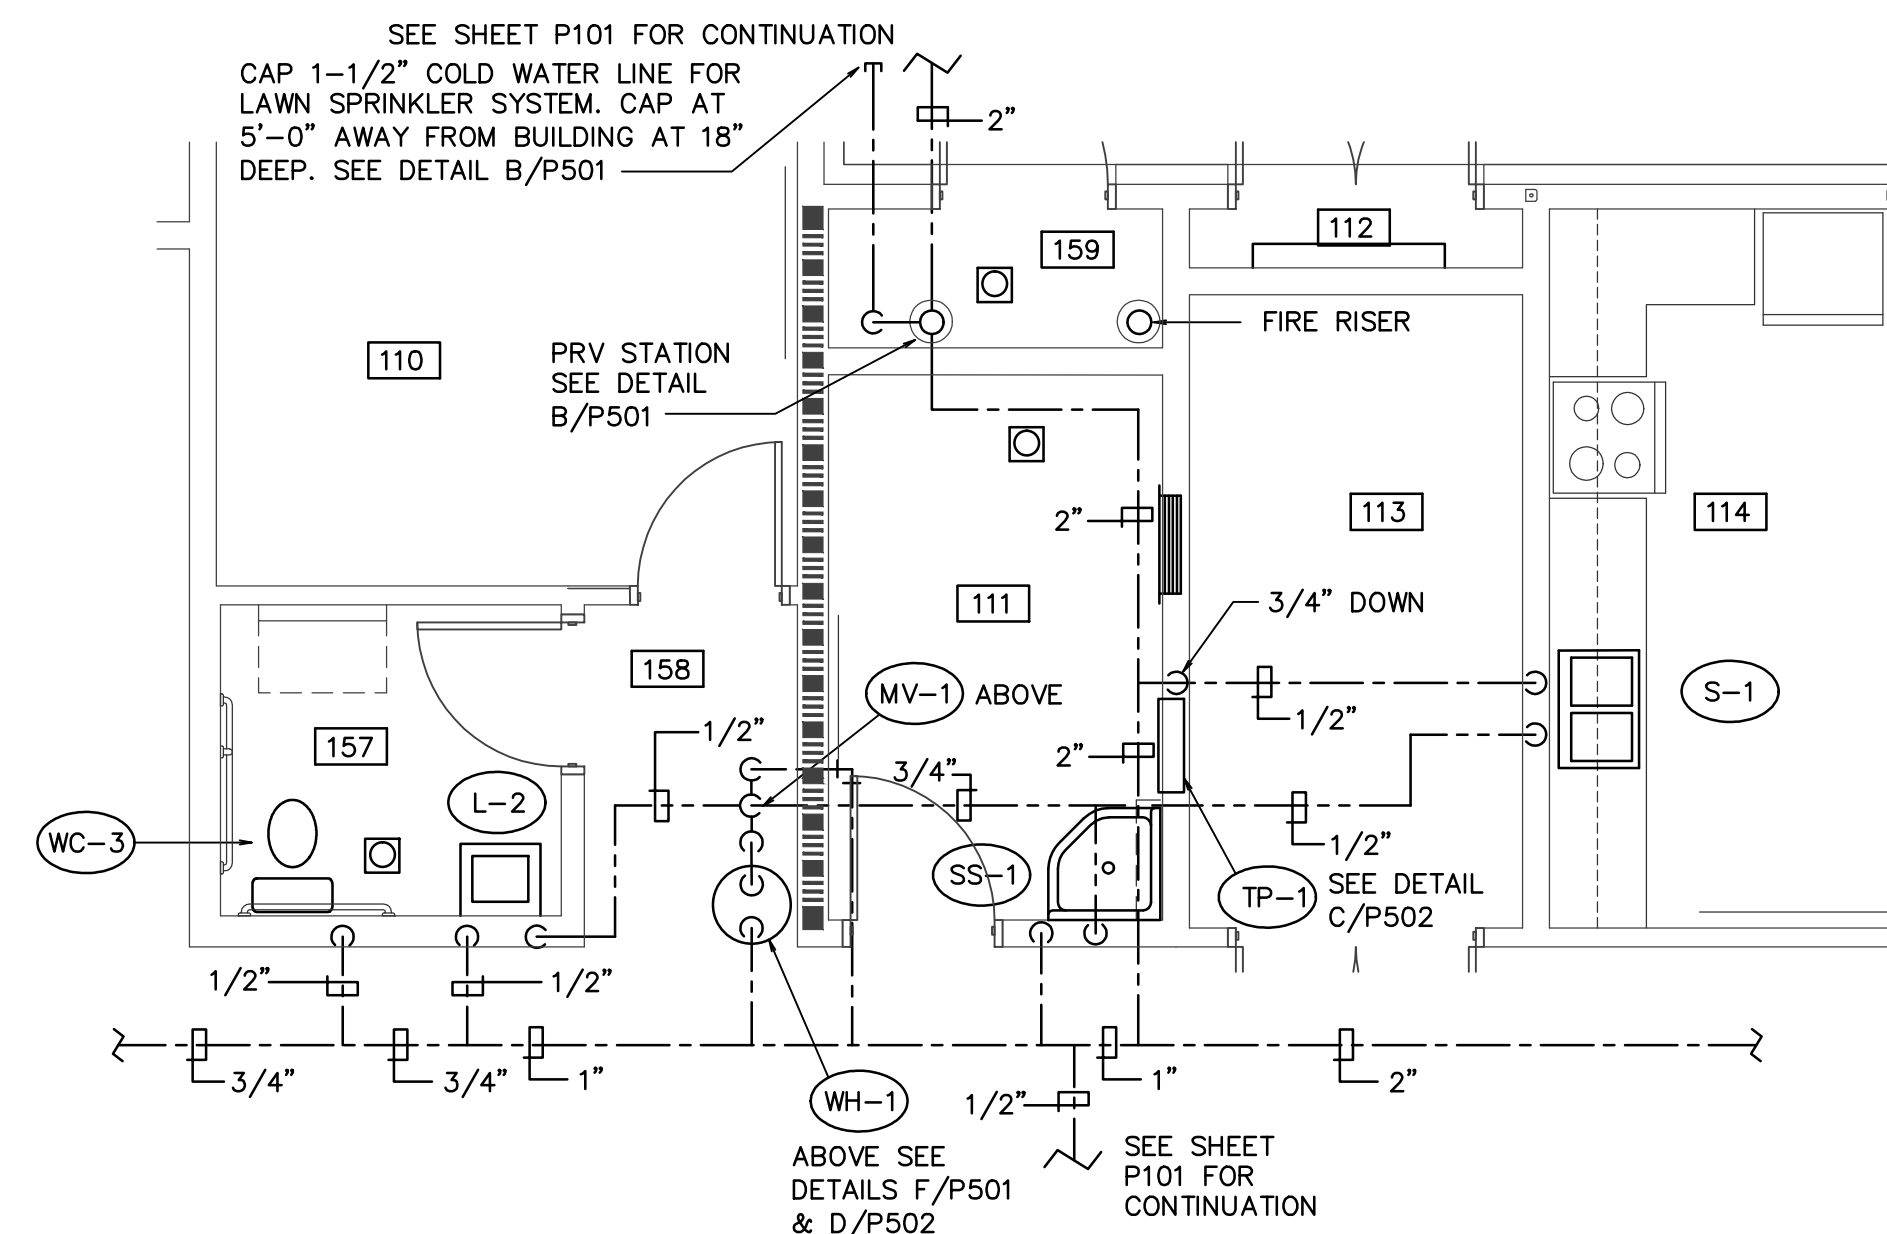
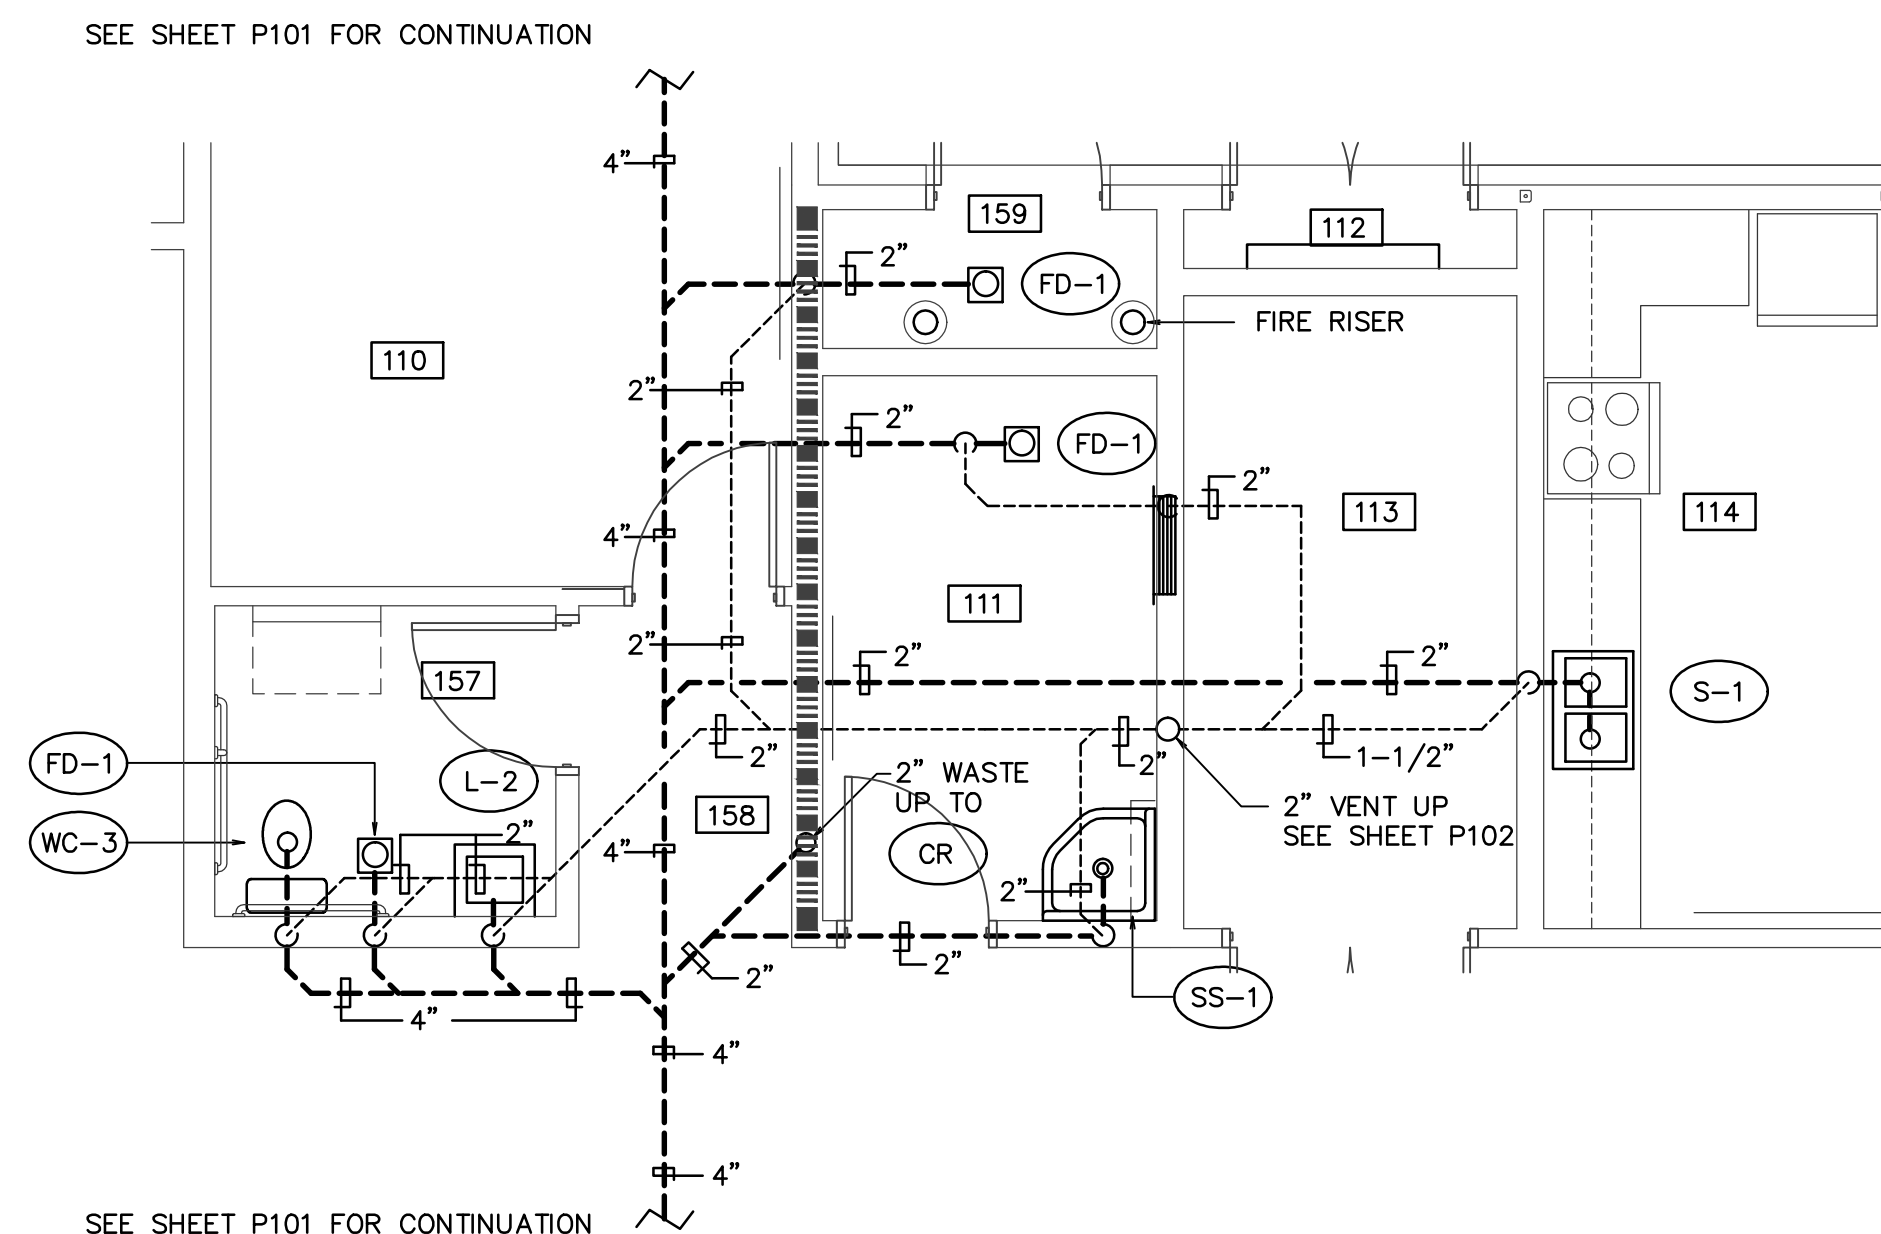
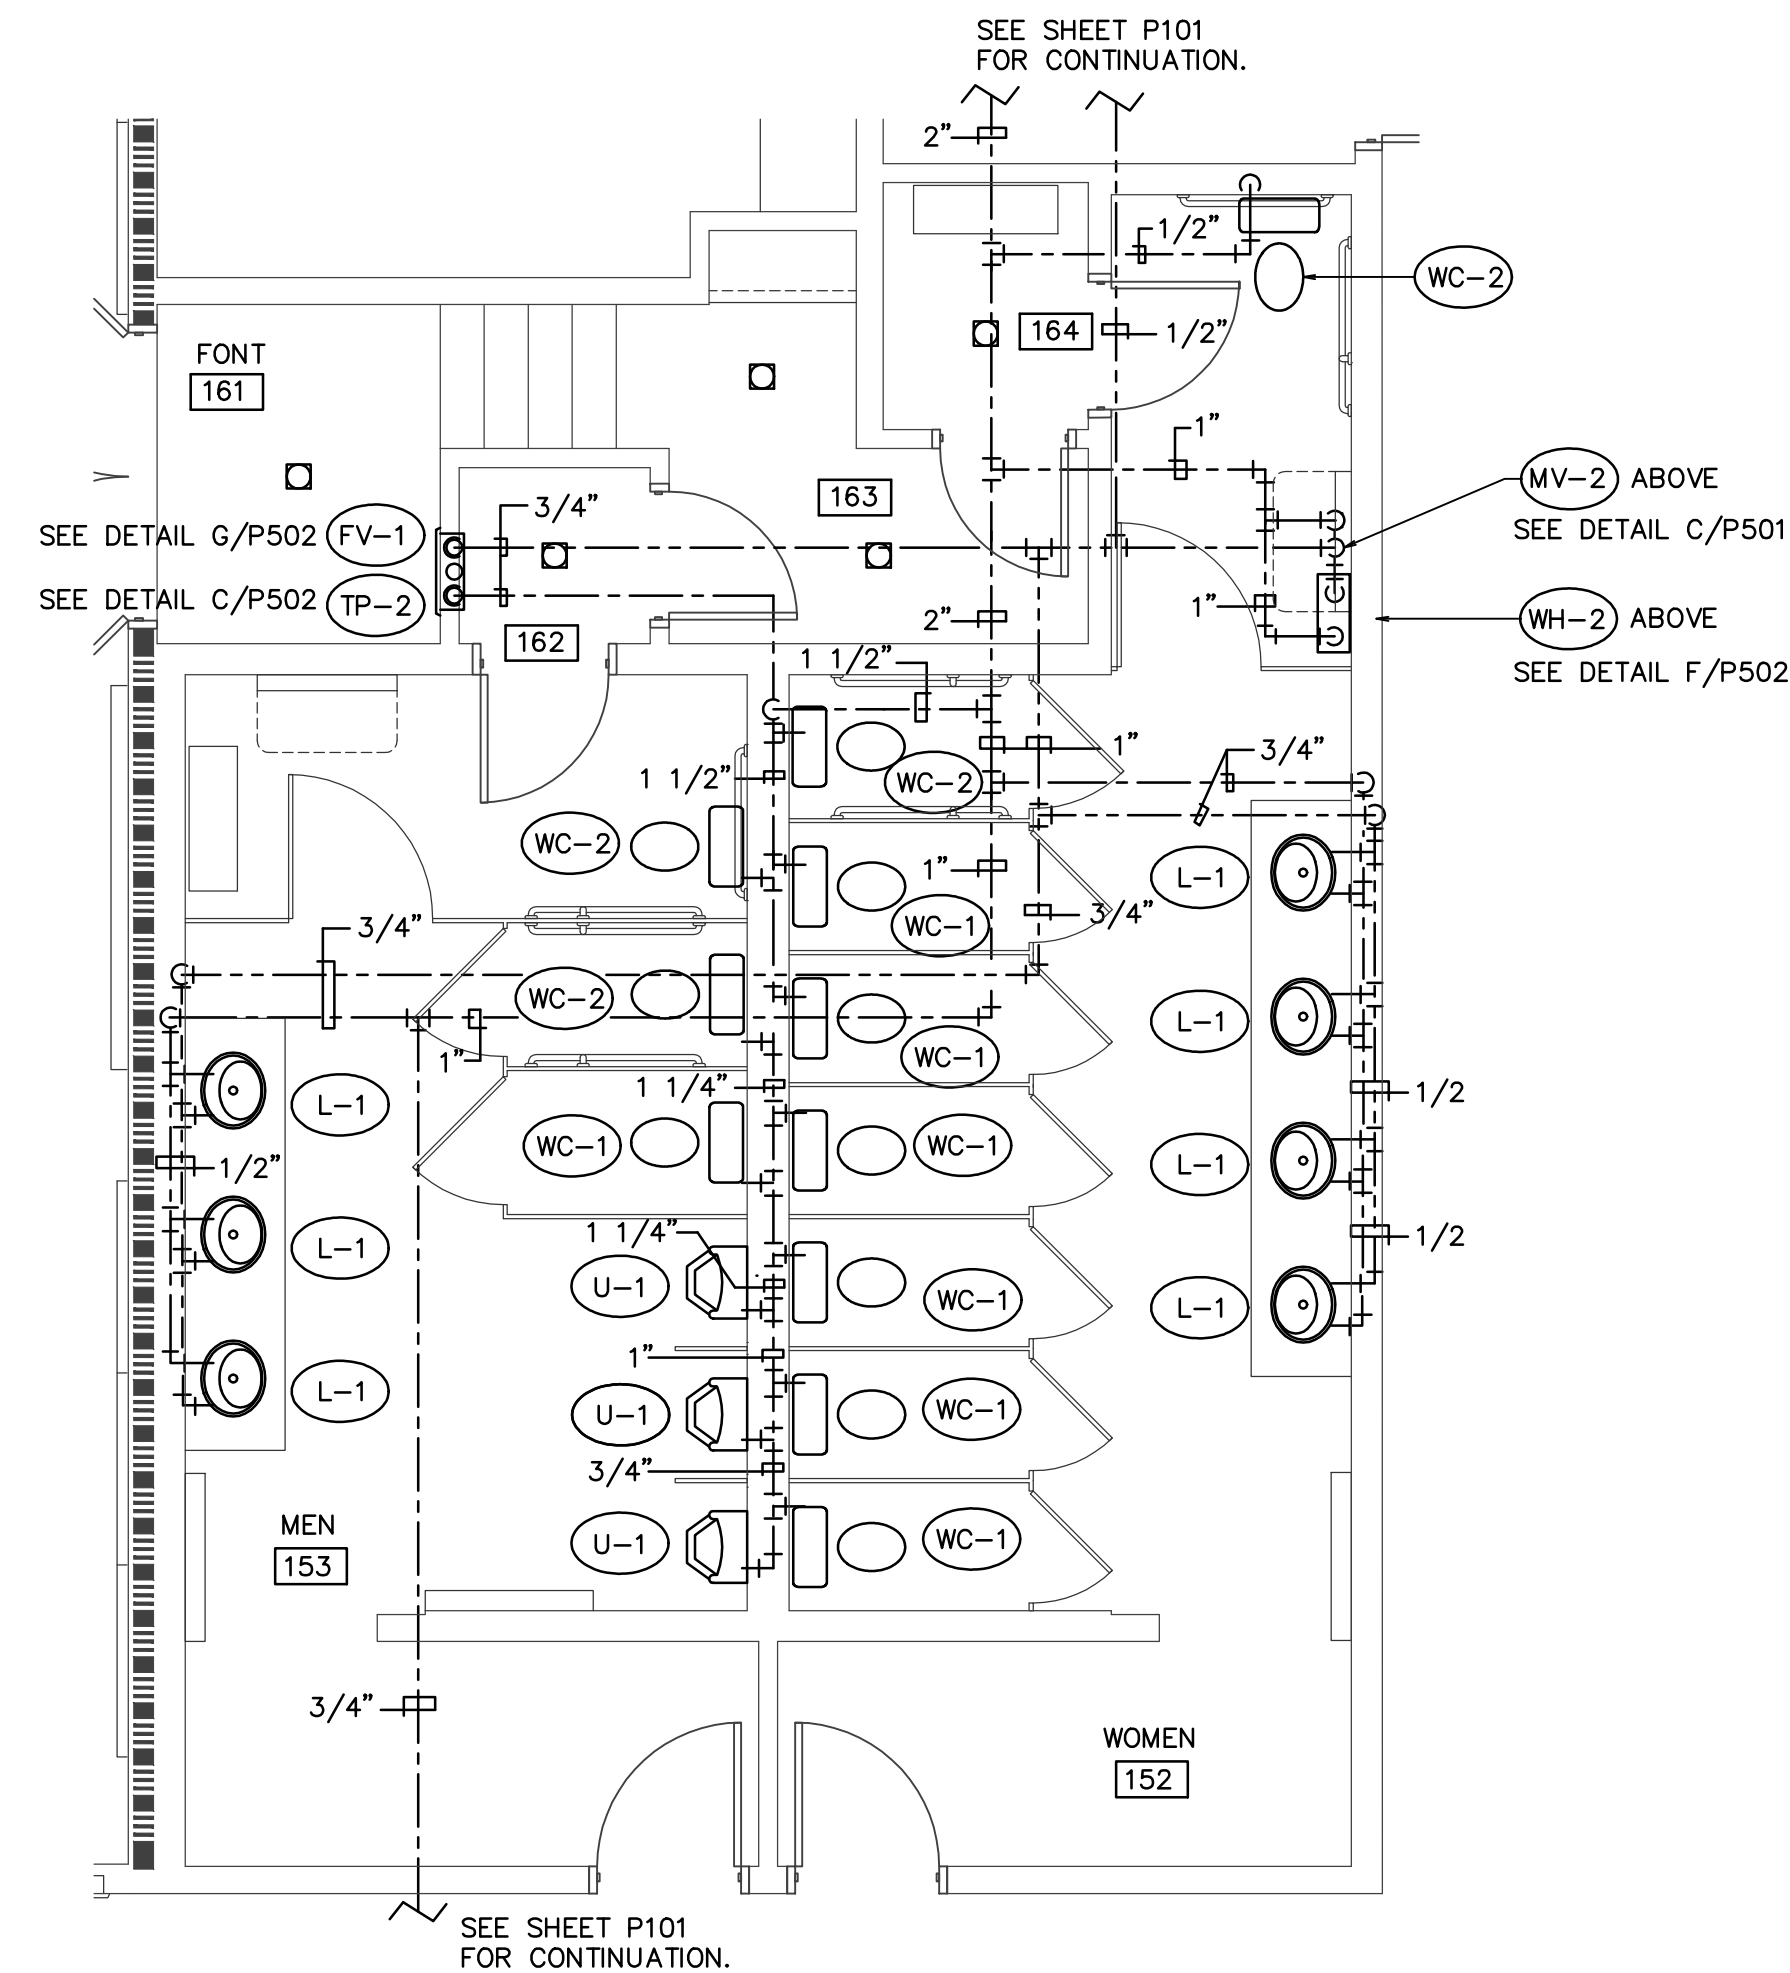


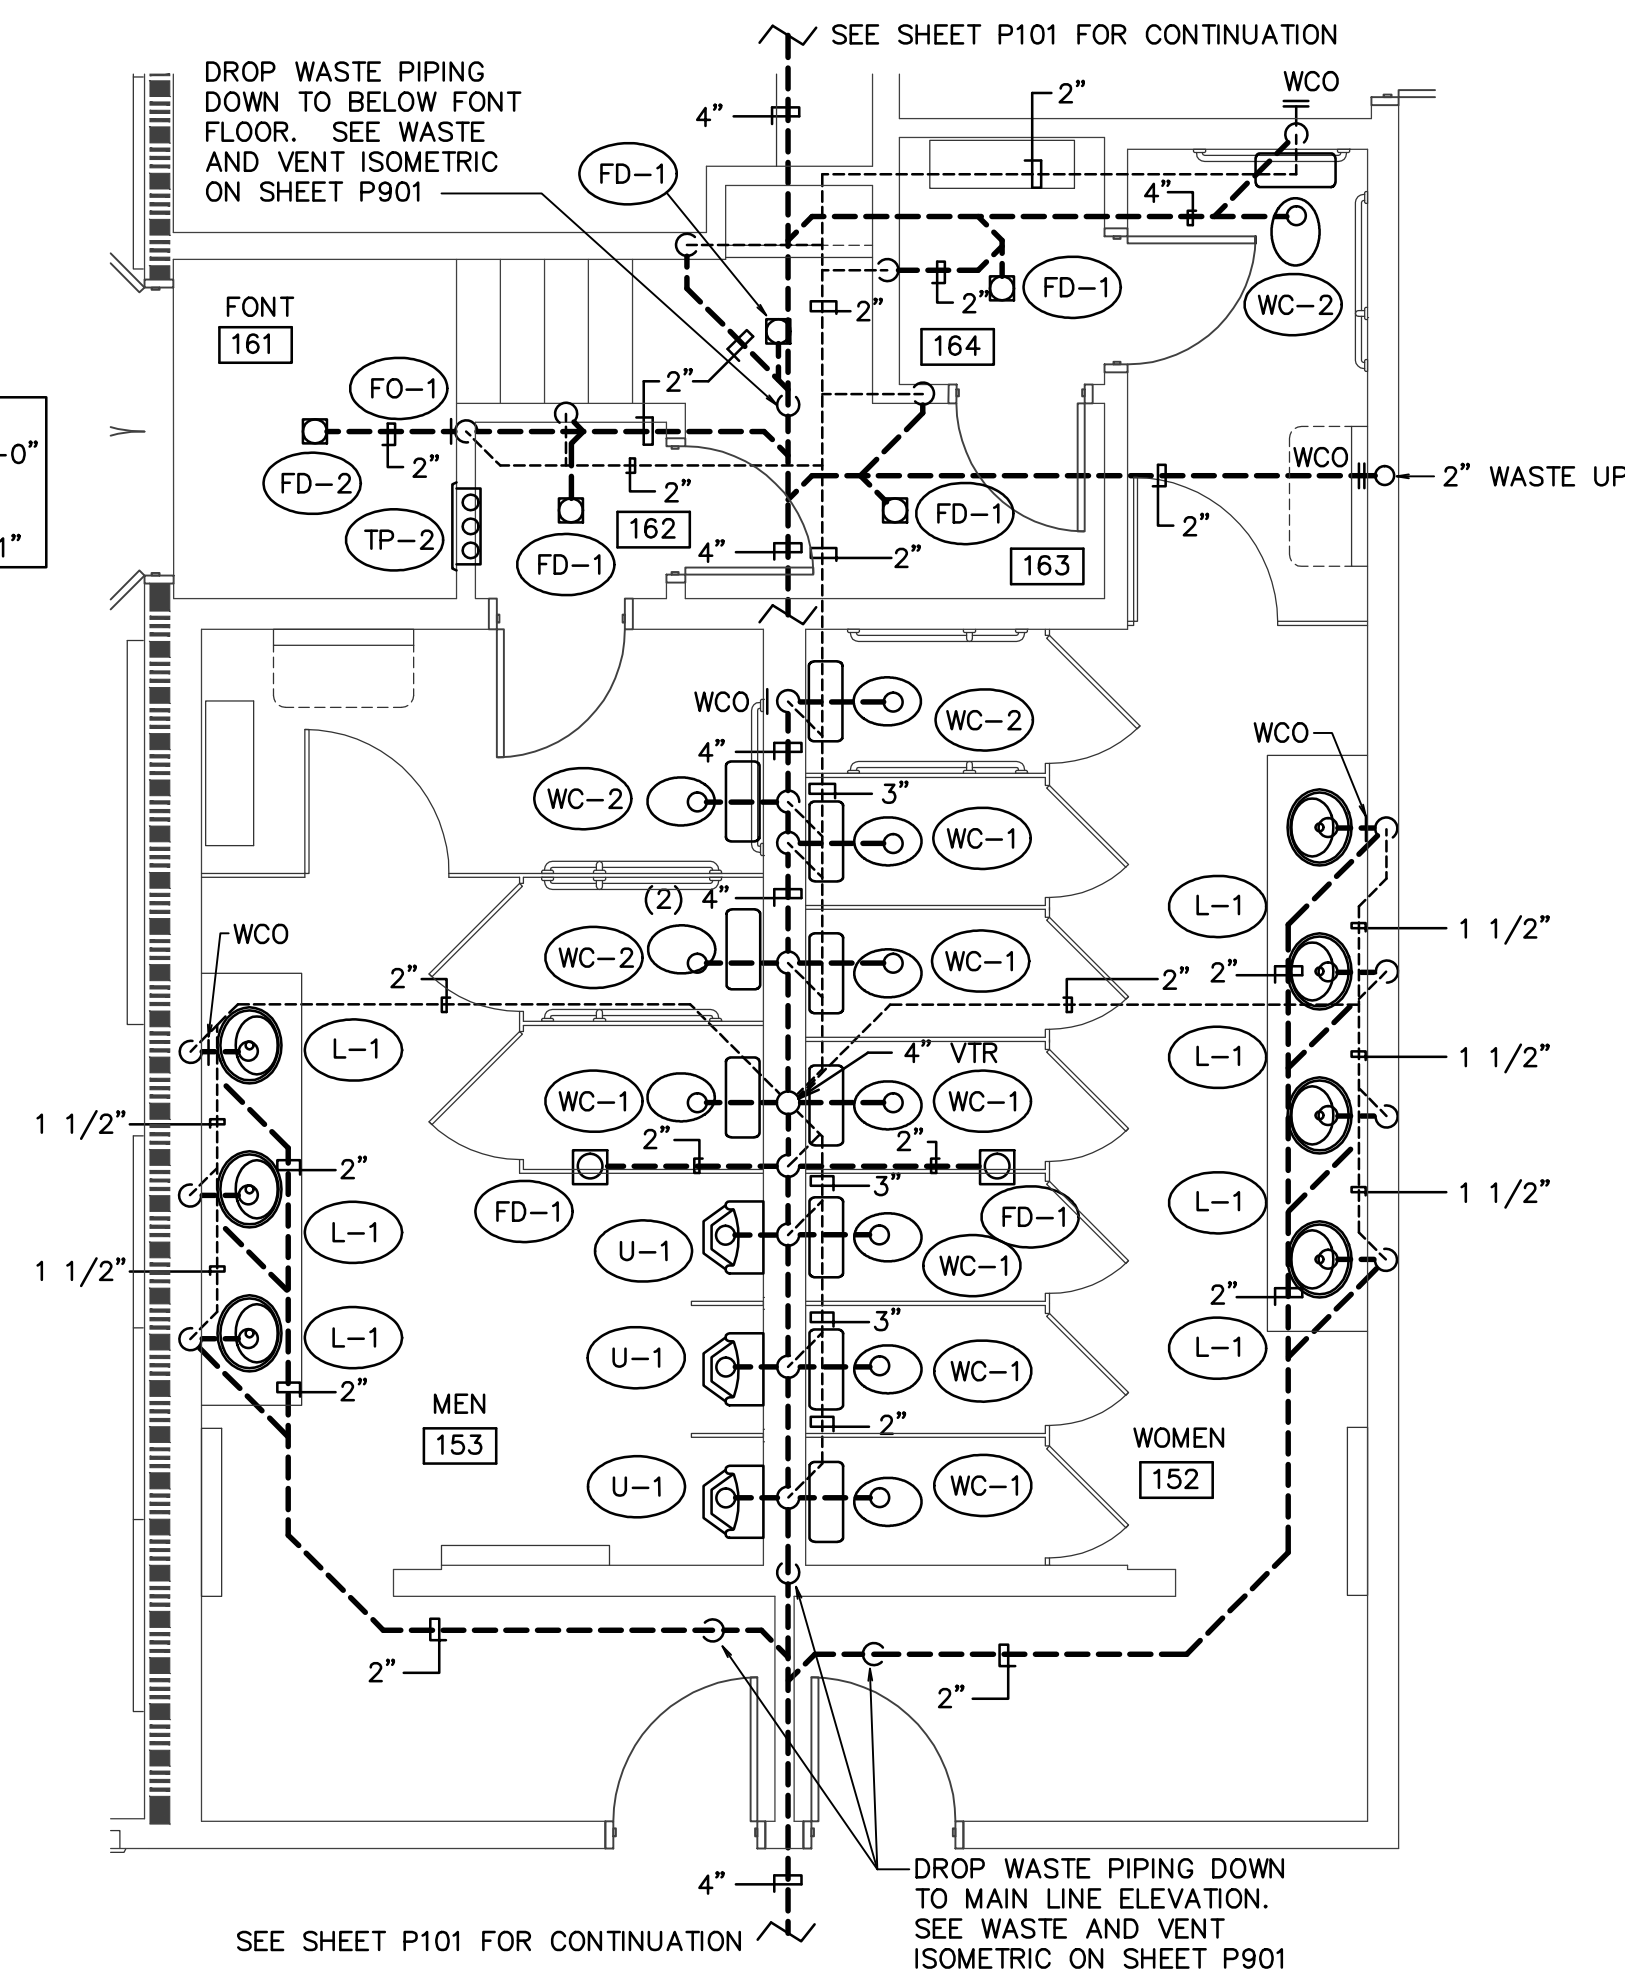

ORIGINAL DRAWING SIGNED BY: DWAYNE C. SUDNEEKS
DATE ORIGINAL SIGNED: Sep 01, 2016
ORIGINAL ON FILE AT ENGINEERED SYSTEMS ASSOCIATES
1355 EAST CENTER, POCATELLO, IDAHO 83201

Engineered Systems Associates
1355 EAST CENTER
POCATELLO, IDAHO 83201
PHONE: (208) 233-0501
FAX: (208) 233-0529
EMAIL: esa@engsystems.com
ESA JOB NUMBER: 15001

Architect / Engineer:
nbwarchitects p.a.
ARCHITECTURE / PLANNING / INTERIORS
SCOTT NELSON AIA, KEVIN R. BOOBY AIA, JAMES H. WYATT AIA
900 JOHN BOHNS PARKWAY, P.O. BOX 2212 - IDAHO FALLS, IDAHO 83402-2212
(208) 322-8775 (F) 208-322-8783 (W) www.nbwarchitects.com

Stamp:

Billings Sweet Grass Creek
Heritage 98
Billings Montana Stake
2620 54th Street W.
Billings Montana 59106

Project for:
THE CHURCH OF JESUS CHRIST OF LATTER-DAY SAINTS

Mark	Date (m.d.y)	Description

Project Number: 15047
Plan Series: HER-TRA-98-20
Property Number: 501-1850

Sheet Title:
LARGE SCALE PLUMBING PLANS

Sheet:
P401