


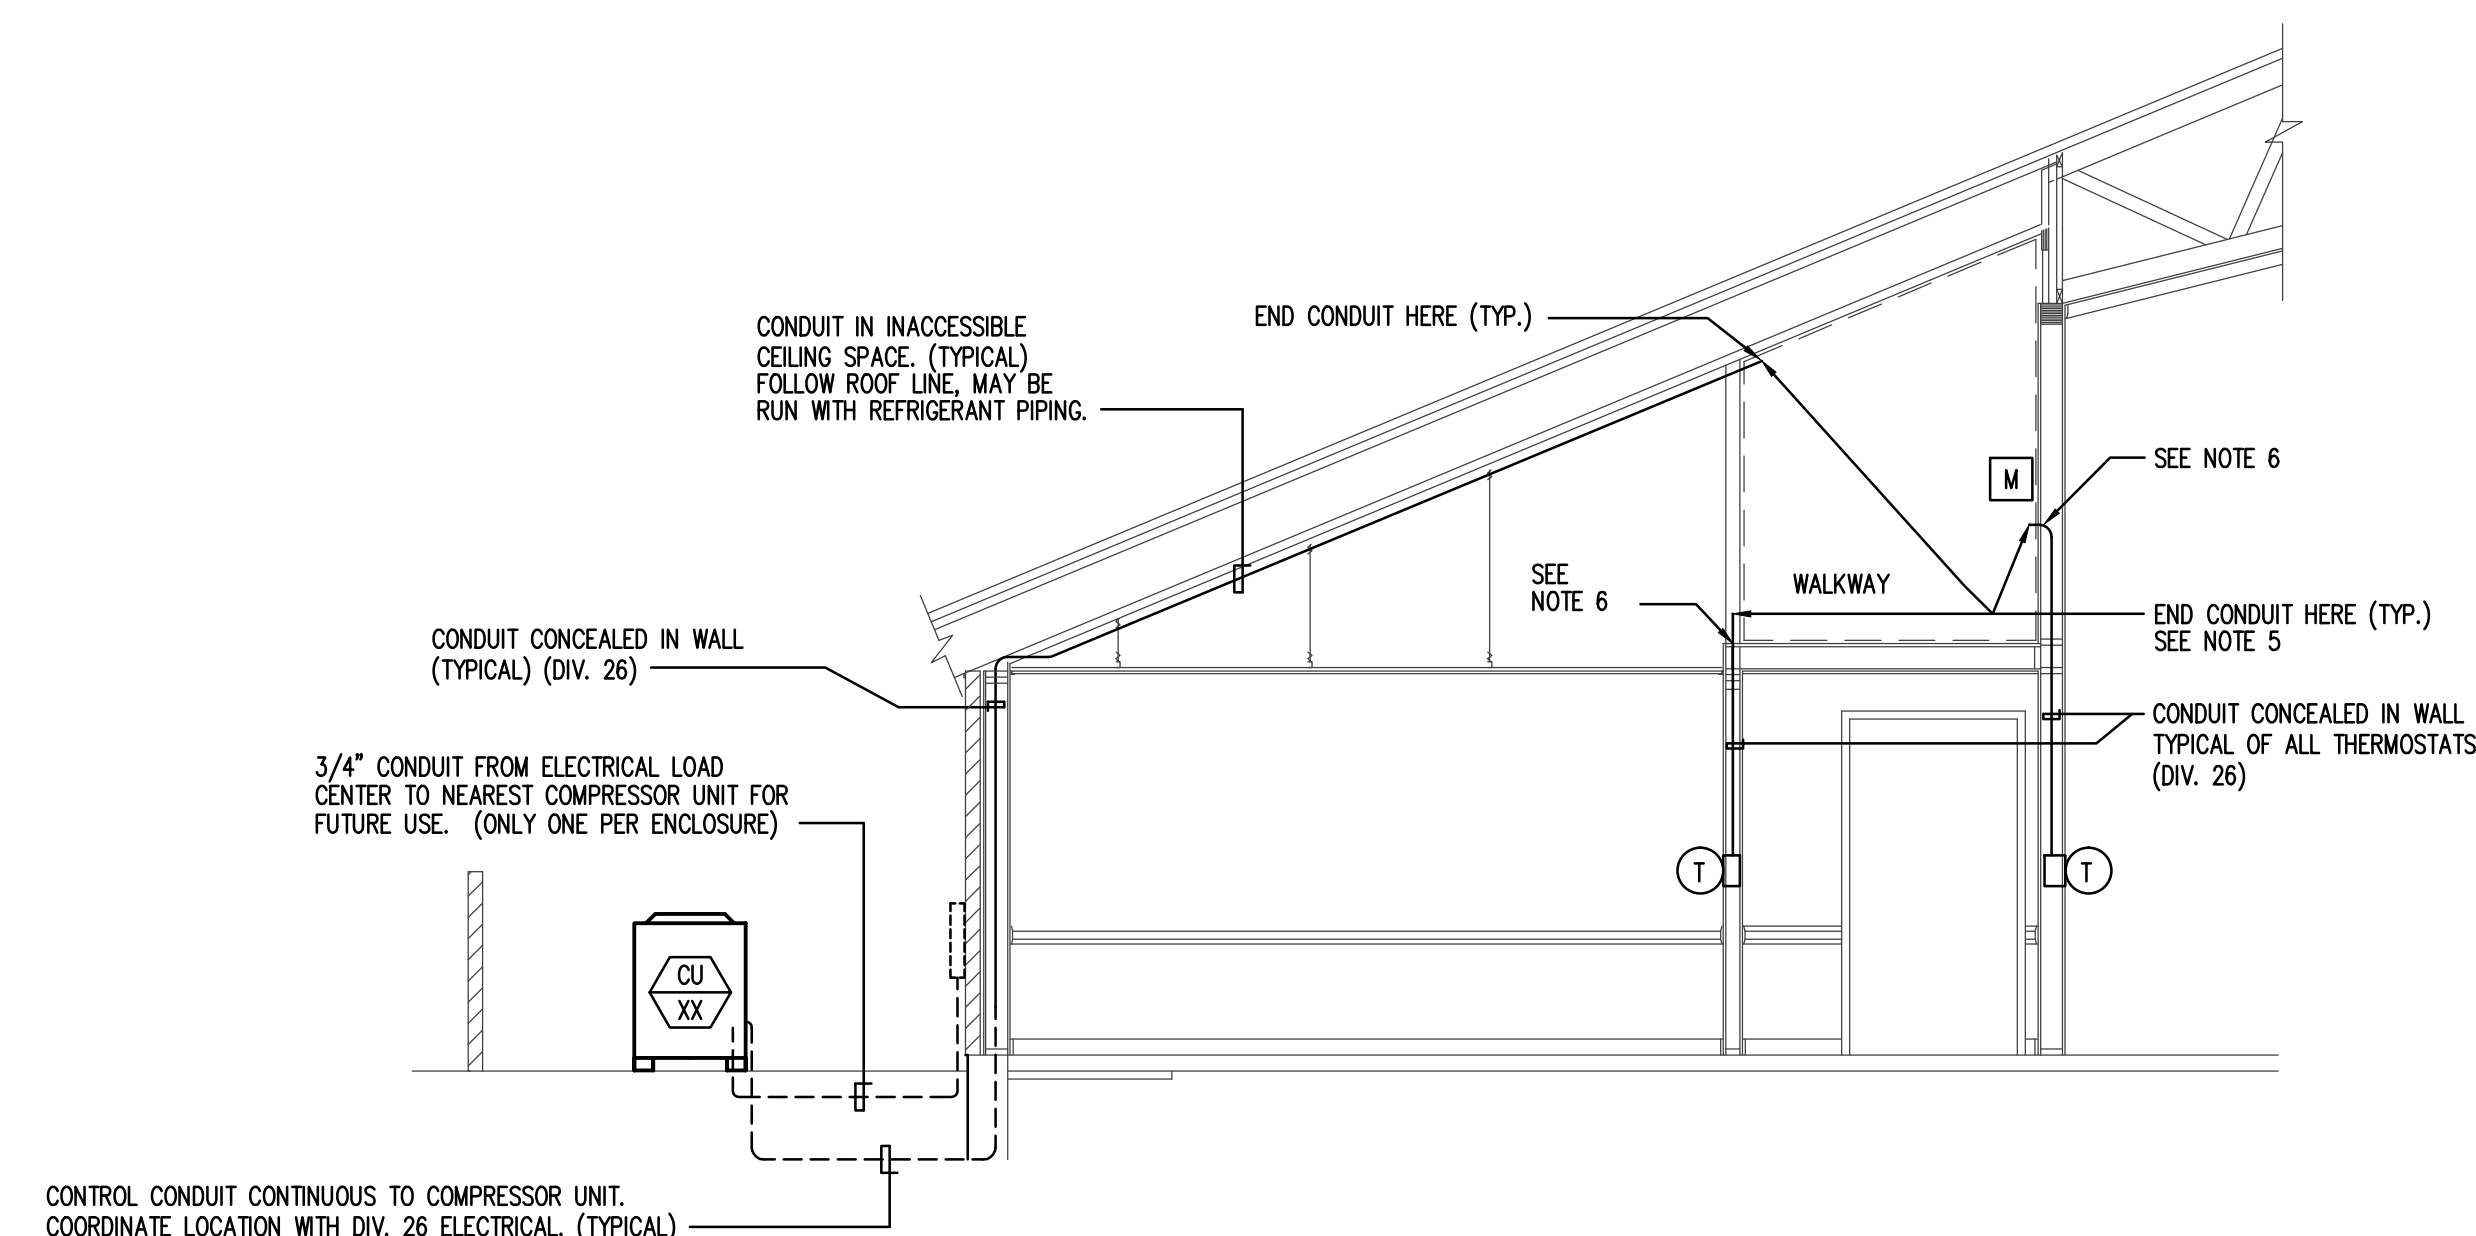

NOTE:
ALL TEMPERATURE CONTROL CONDUIT SHALL
BE FURNISHED AND INSTALLED BY DIVISION 26.

SYMBOLS

- | | |
|---|--|
|  | EQUIPMENT INTERFACE MODULE (DIV 23). MOUNT MODULE IN ACCESSIBLE LOCATION ON HORIZONTAL WALL NEAR ASSOCIATED FURNACE. |
|  | RELAY PANEL (DIV 23) MOUNT 5'-0" TO BOTTOM OF CABINET |
|  | THERMOSTAT OUTLET (DIV 26) |
|  | RIG MODULE (DIV 23) |
|  | PORTABLE COMFORT CONTROL |
|  | WIRELESS INDOOR AIR SENSOR |
|  | WIRELESS OUTDOOR AIR SENSOR. SEE NOTE 9, SHEET ME701. |
|  | CO ₂ SENSOR (DIV 23) INSTALL UPSTREAM OF RELIEF OR OUTSIDE AIR CONNECTION. REFER TO SECTION 2/M302. (SIMILAR FOR ALL) |
|  | COMBINATION EIM AND THERMAL OVERLOAD DISCONNECT (ECONNECT) |
|  | THERMOSTAT (ECONNECT) |

NOTES:

1. BOXES FOR THERMOSTAT (T) OUTLETS SHALL BE 2"x4" WITH LONG DIMENSION VERTICAL. USE METAL BRACKET OF COVER PLATE ASSEMBLY TO MOUNT THERMOSTAT HORIZONTAL.
2. CONDUIT TO BE 1/2" UNLESS NOTED OTHERWISE.
3. TEMPERATURE CONTROL WIRING THAT IS NOT IN CONDUIT SHALL BE RUN PARALLEL AND PERPENDICULAR TO BUILDING CONSTRUCTION LINES. SEE SPECIFICATIONS FOR ACCEPTABLE FASTENING METHODS AND MAXIMUM ALLOWABLE SPACING BETWEEN FASTENERS.
4. TEMPERATURE CONTROL WIRING THAT IS NOT IN CONDUIT SHALL BE LABELED. PROVIDE A LABEL AT ALL POINTS WHERE TEMPERATURE CONTROL WIRING ENTERS CONDUIT AND AT CONNECTIONS TO DEVICES.
5. SEAL OPEN END OF CONDUIT AIR-TIGHT AROUND THERMOSTAT WIRE WITH SEALANT COMPOUND. SEE SPECS FOR APPROVED PRODUCT.
6. SEAL ANNULAR SPACE BETWEEN CONDUIT AND OPENING IN FLOOR OR WALL WITH SEALANT COMPOUND. SEE SPECS FOR APPROVED PRODUCT.
7. SEAL OPEN END OF CONDUIT AT J-BOX AIR TIGHT AROUND THERMOSTAT WIRE. SEAL ALL AIR GAPS AROUND J-BOX TO ISOLATE J-BOX FROM WALL CAVITY. SEAL BACK OF THERMOSTAT AROUND WIRES. PACK J-BOX TIGHT WITH GLASS FIBER BATT INSULATION. USE SEALING COMPOUND SPECIFICALLY MADE FOR PENETRATION AND AIR CONDITIONING APPLICATIONS. SEE SPECIFICATIONS FOR APPROVED PRODUCTS.

1. AUTOMATIC TEMPERATURE CONTROL — FLOOR PLAN
SCALE: 1/16"=1'-0"

nbwarchitects p.a.
ARCHITECTURE / PLANNING / INTERIORS
SCOTTI NIELSON ALAN KREVIN ROTHLY AIA JAMES H. WYATT AIA
Architect / Engineer:

Stamp

**New Meetinghouse for:
Iona South Stake
Heritage 09TSC**

Project for:

**THE CHURCH OF
JESUS CHRIST
OF LATTER-DAY SAINTS**


[illegible]

Project Number:	16065
Plan Series:	HET-SDS-09
Property Number:	500-5990

Sheet Title:
AUTOMATIC
TEMPERATURE
CONTROL
FLOOR PLAN

Sheet:

ME101

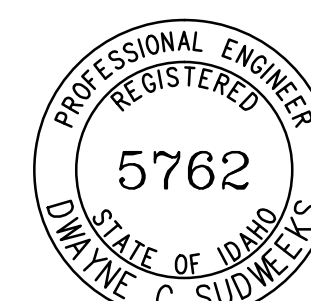
**Engineered
Systems
Associates**

1355 EAST CENTER
POCATELLO, IDAHO 83201
PHONE: (208) 233-0500
FAX: (208) 233-0520
EMAIL: esa@engsystems.com

ESA JOB NUMBER: 1608.3