




**A** **LAWN IRRIGATION STOP & WASTE VALVE ASSEMBLY DETAIL**  
SCALE: NONE

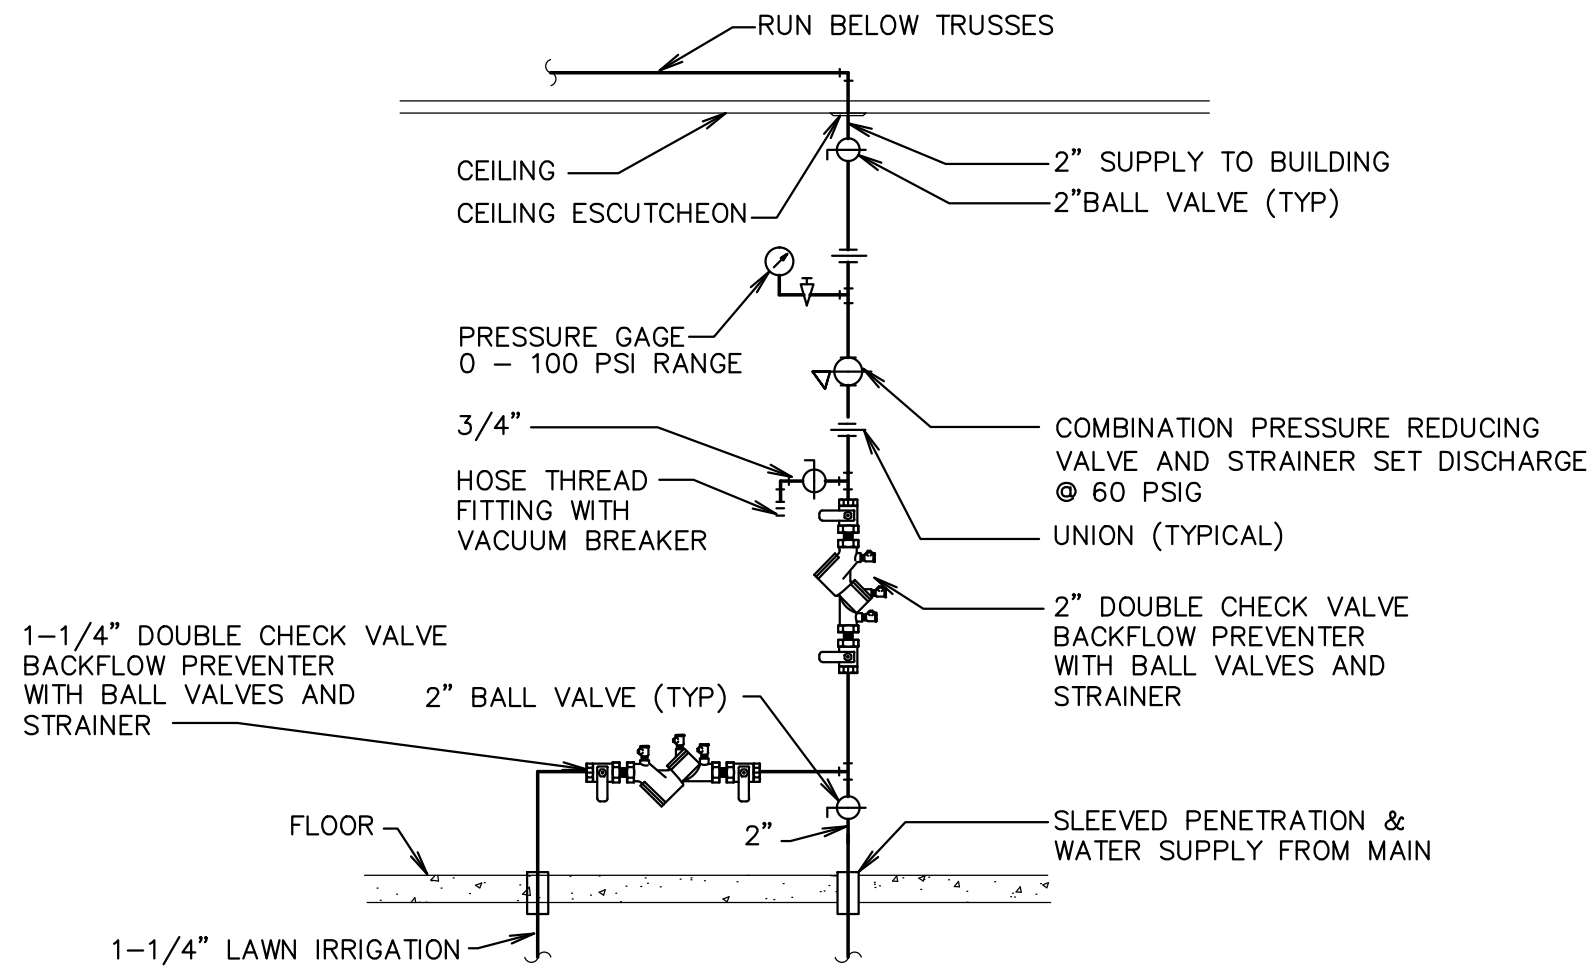


**B** **VERTICAL WATER PRESSURE REDUCING STATION DETAIL**  
SCALE: NONE

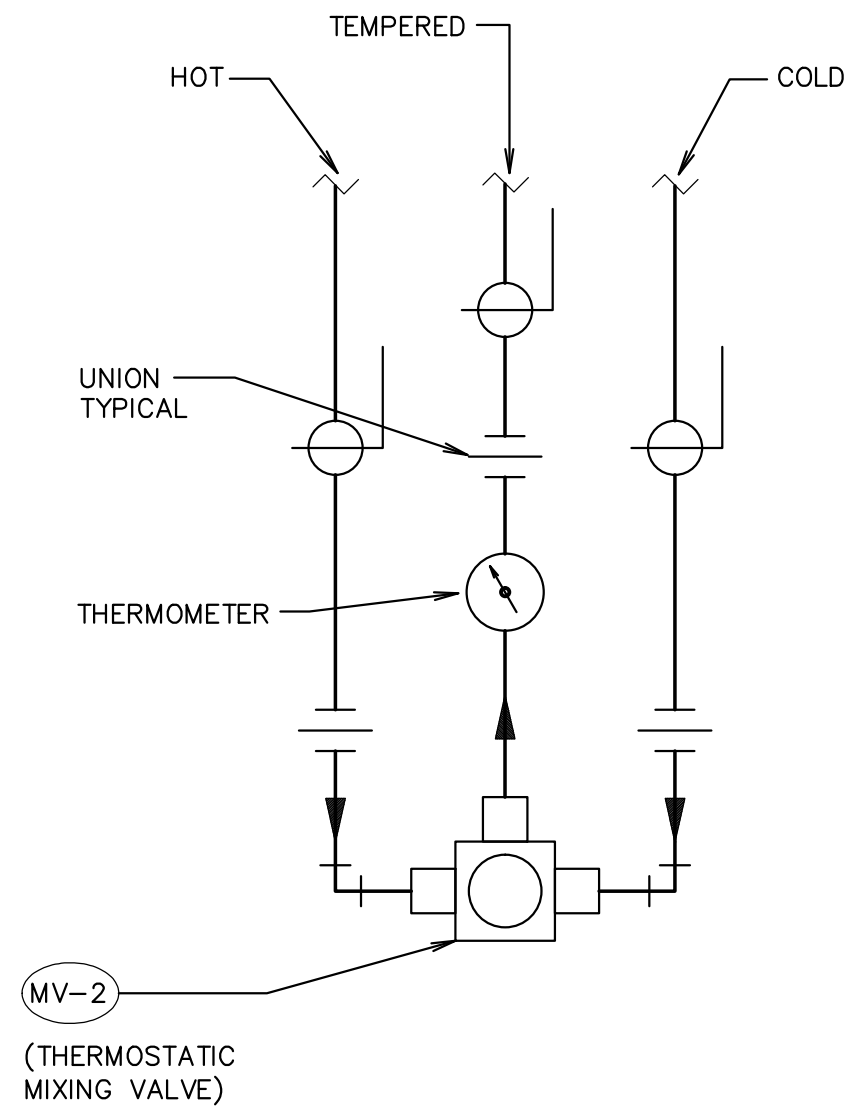


**C** **MIXING VALVE PIPING SCHEME**  
SCALE: NONE

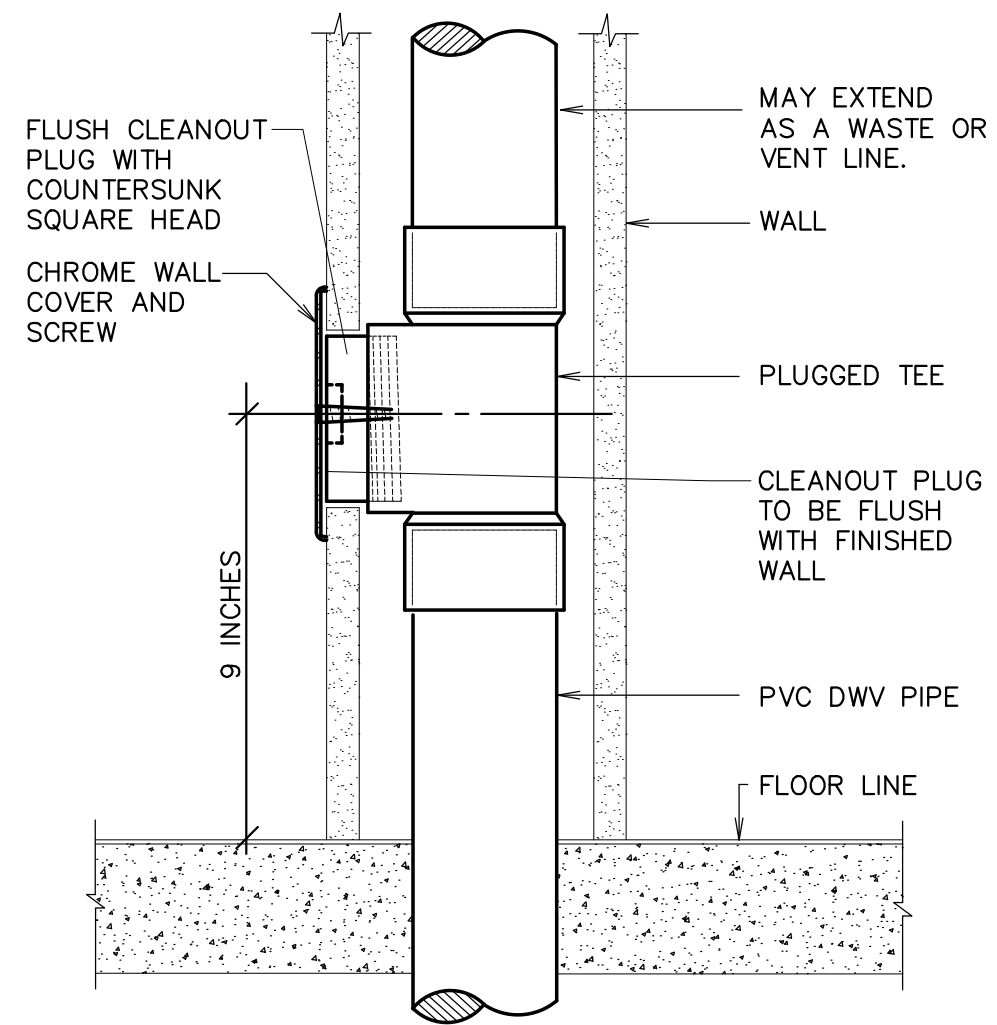

**D** **WALL CLEANOUT DETAIL**  
SCALE: NONE

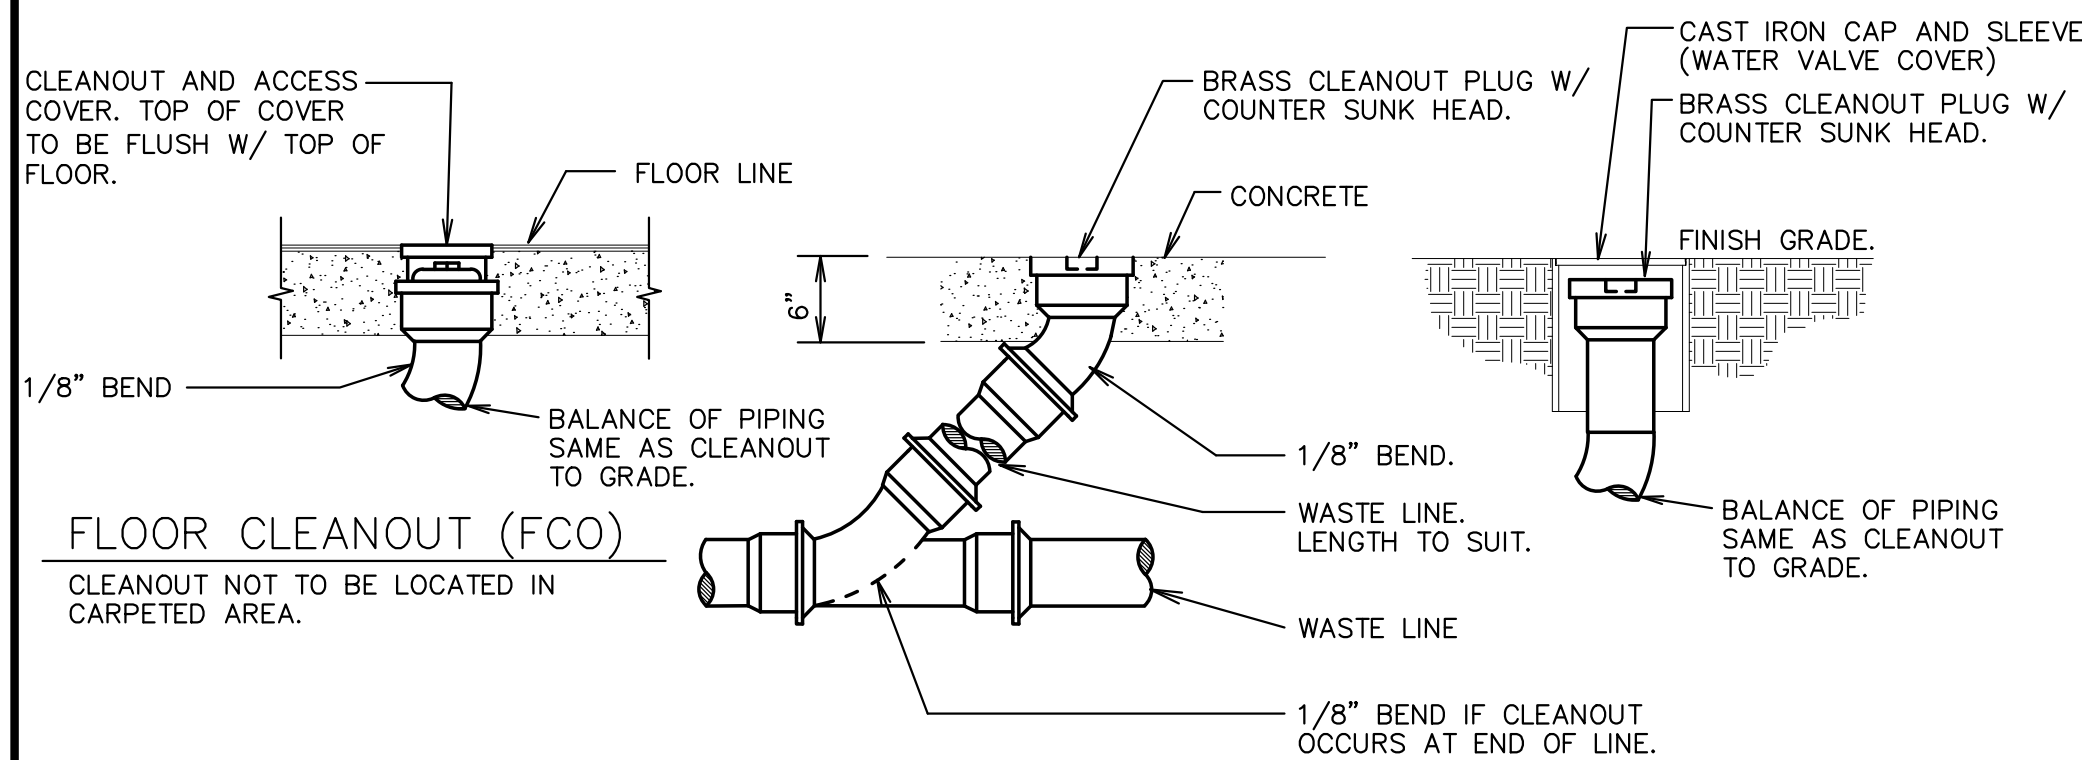


**E** **CLEANOUT DETAILS**  
SCALE: NONE

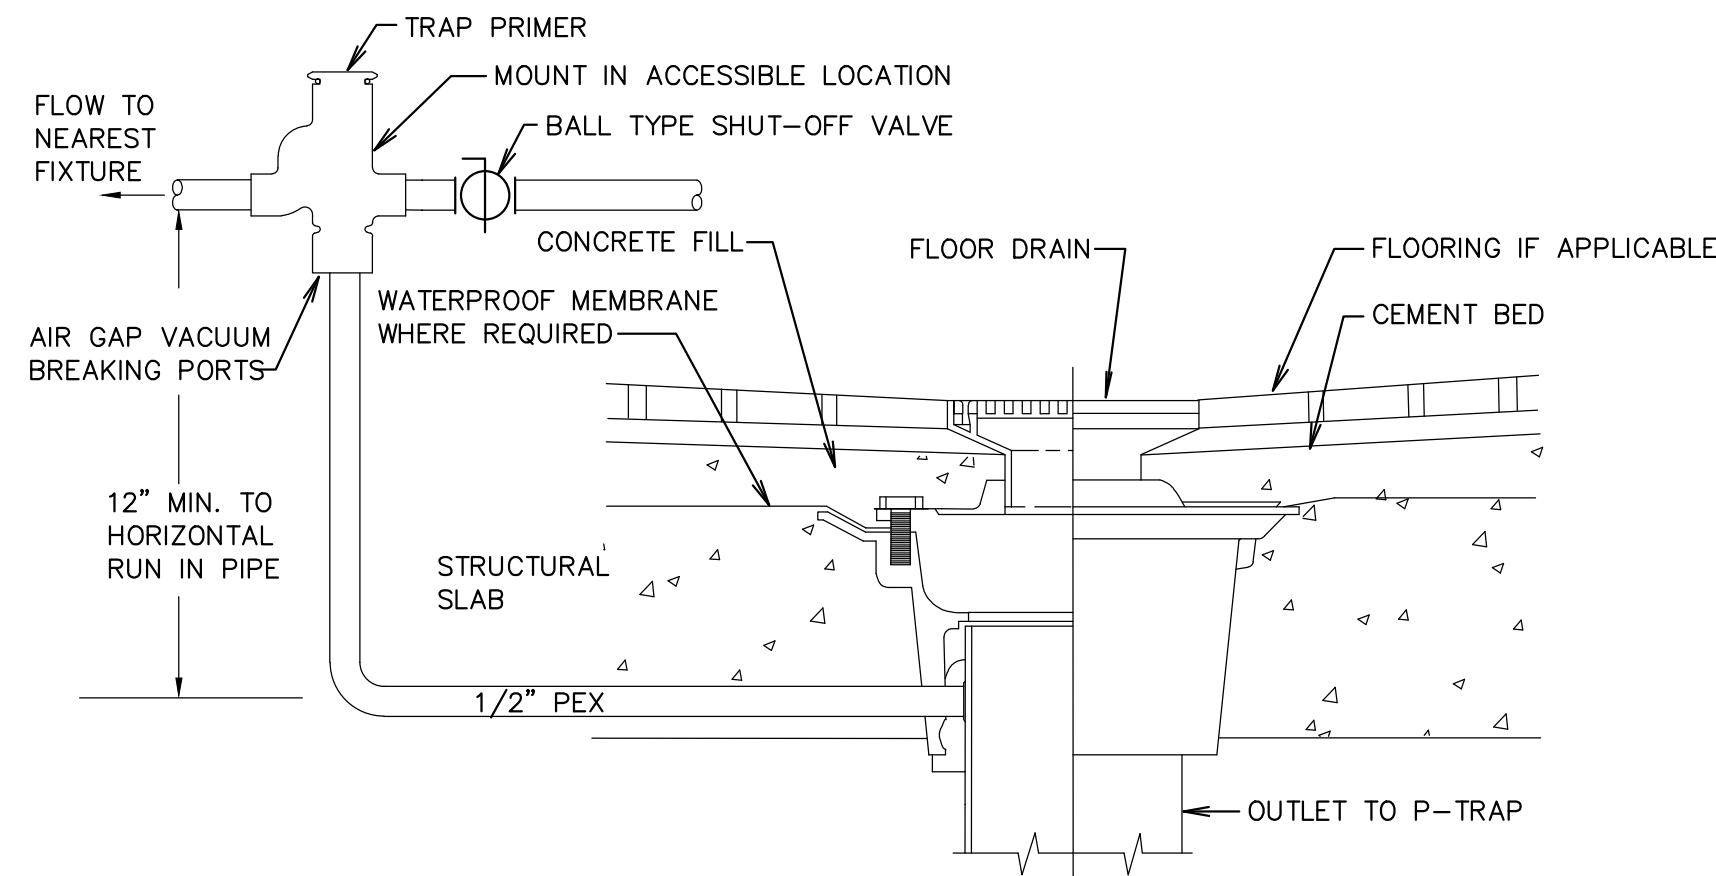


**F** **TRAP PRIMER DETAIL**  
SCALE: NONE

**G** **NOT USED**  
SCALE: NONE

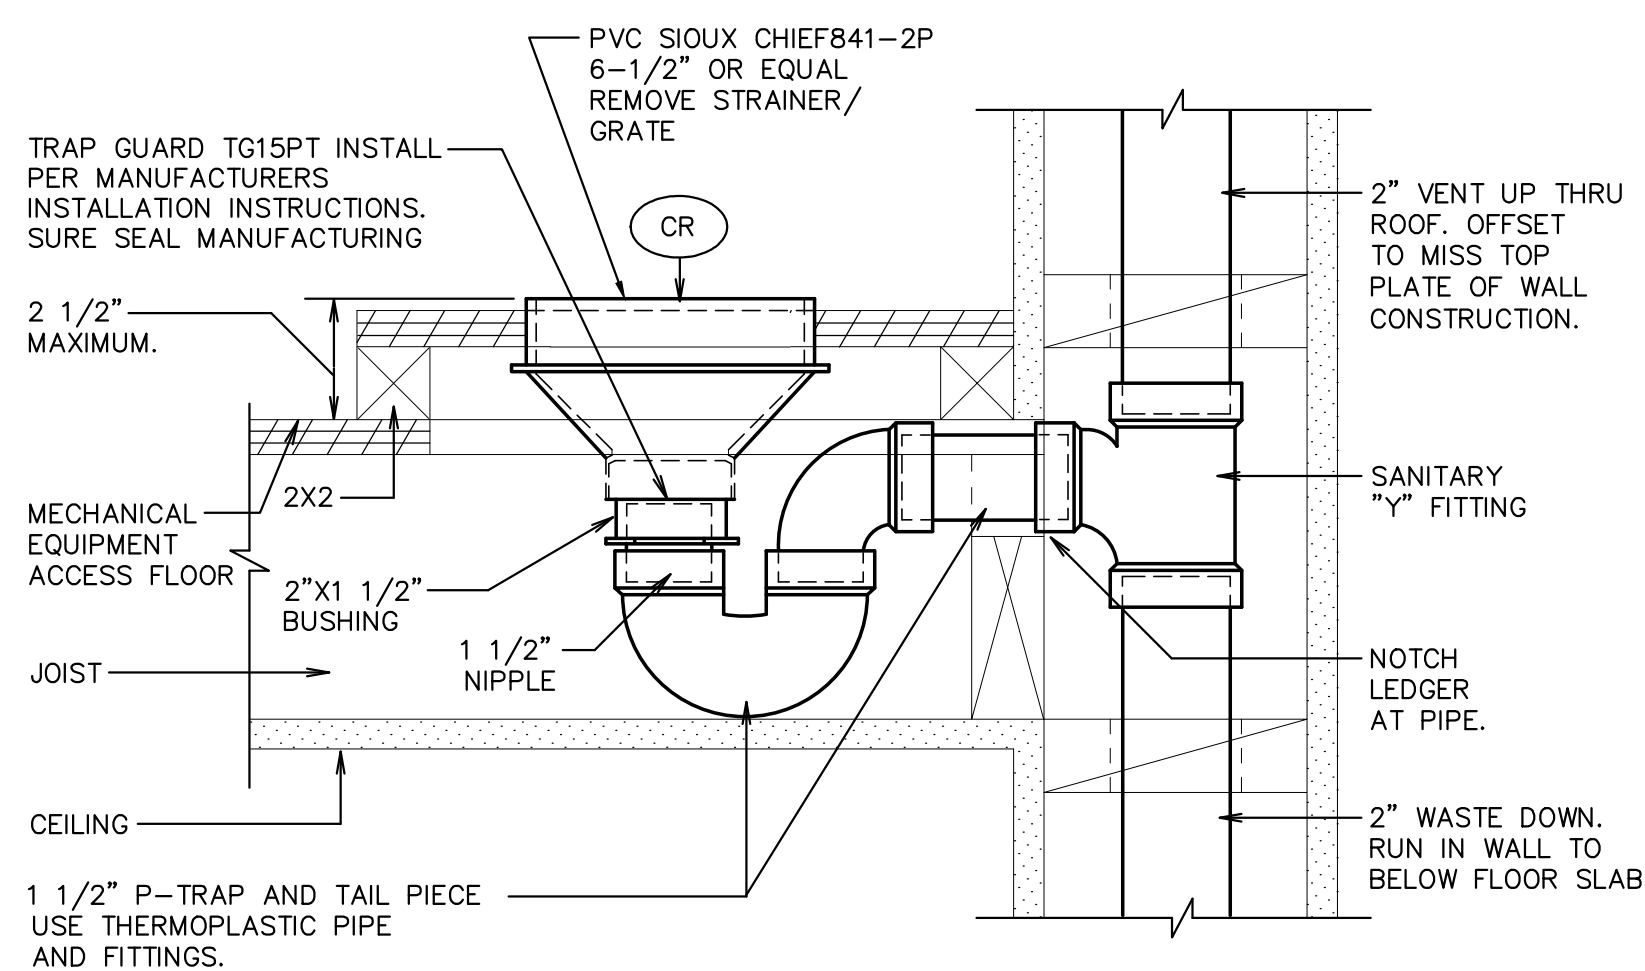


**H** **CONDENSATE RECEIVER DETAIL**  
SCALE: NONE

**I** **NOT USED**  
SCALE: NONE

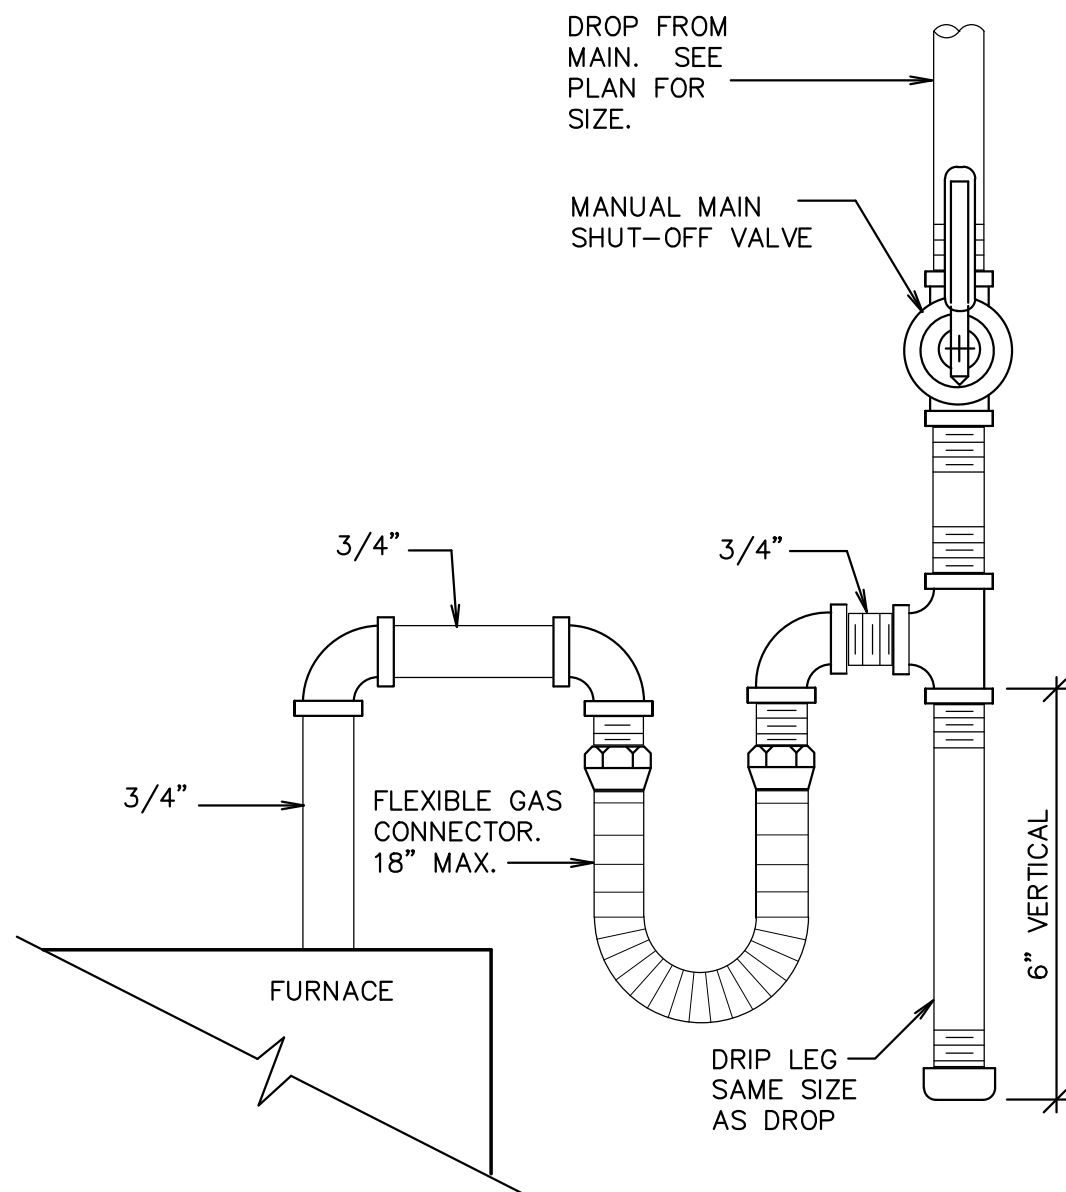

**J** **GAS LINE CONNECTION DETAIL**  
SCALE: NONE

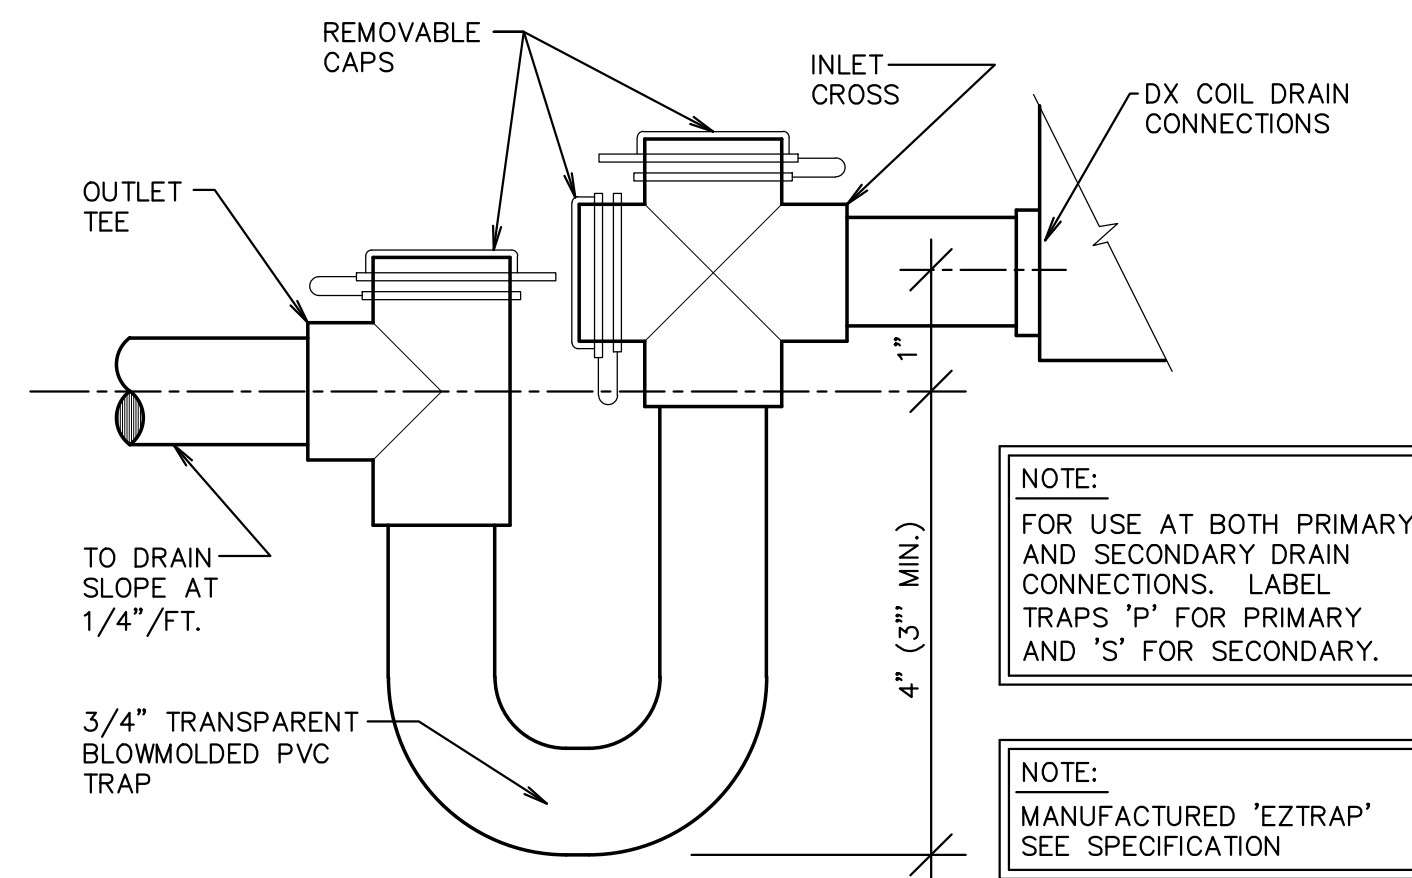

**K** **DX COIL CONDENSATE DRAIN DETAIL**  
SCALE: NONE

ORIGINAL DRAWING SIGNED BY: DWAYNE C. SUDWEEKS  
DATE ORIGINAL SIGNED: Nov 29, 2017  
ORIGINAL ON FILE AT ENGINEERED SYSTEMS ASSOCIATES  
1355 EAST CENTER, POCA TELLO, IDAHO 83201

**Engineered Systems Associates**  
1355 EAST CENTER  
POCA TELLO, IDAHO 83201  
PHONE: (208) 233-0501  
FAX: (208) 233-0529  
EMAIL: esa@engsystems.com  
ESA JOB NUMBER: 17011



Architect / Engineer:  
**nbwarchitects p.a.**  
ARCHITECTURE / PLANNING / INTERIORS  
SCOTT NELSON, AIA, KEVIN R. BOOBY, AIA, JAMES H. WYATT, AIA  
1901 JOHN BOOBY DRIVE, P.O. BOX 2212, IDAHO FALLS, IDAHO 83402-2212  
(208) 522-8773 (208) 522-8785 (ID) www.nbwarchitects.com

Stamp:

New Building for:  
**Thunder Ridge Sr. Seminary**  
**S&I**  
Project Address

Project for:  
**THE CHURCH OF JESUS CHRIST OF LATTER-DAY SAINTS**

Mark	Date (y-m-d)	Description

Project Number:  
**16059**  
Plan Series:  
**SEM07-04-10**  
Property Number:  
**\*\*\***

Sheet Title:  
**PLUMBING DETAILS**

Sheet:  
**P501**