



F:\17042 JUNIPER SANDS APTS\17042 M1.dwg Jun 14, 2017 3:26pm

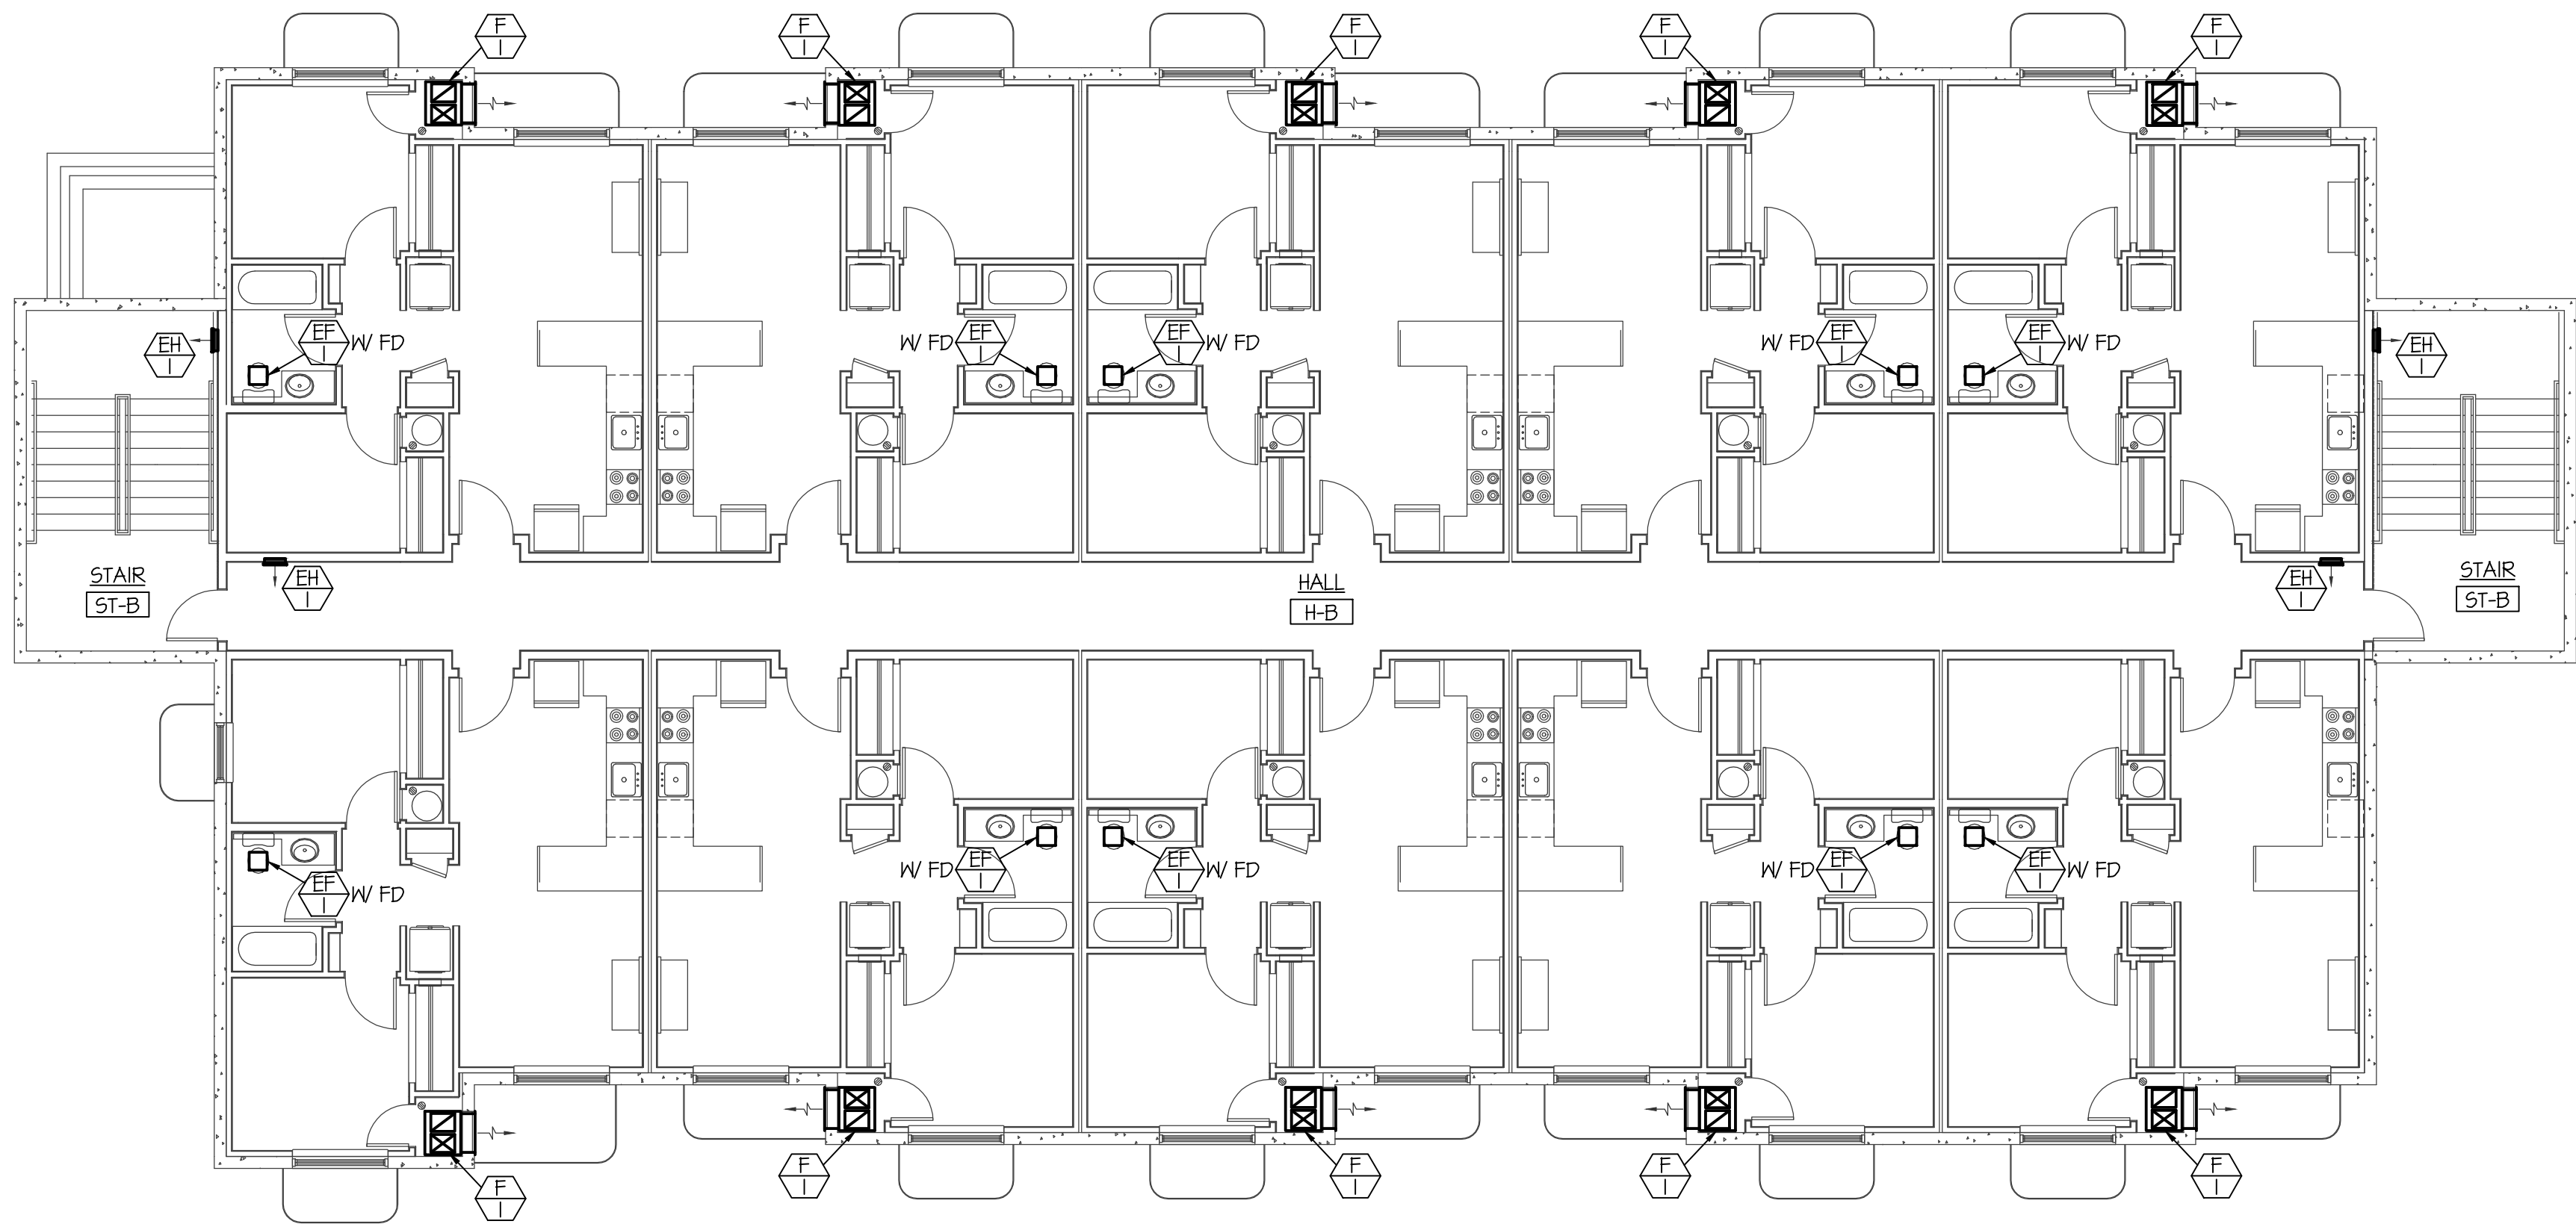

**BLDG. 1 BASEMENT MECH. FLOOR PLAN**  
SCALE: 1/8" = 1'-0"



**NOTE:**  
SEE TYPICAL APT. LARGE SCALE MECHANICAL FLOOR PLANS ON SHEET M2.0 FOR DUCTWORK AND EQUIPMENT LOCATED IN EACH APT.

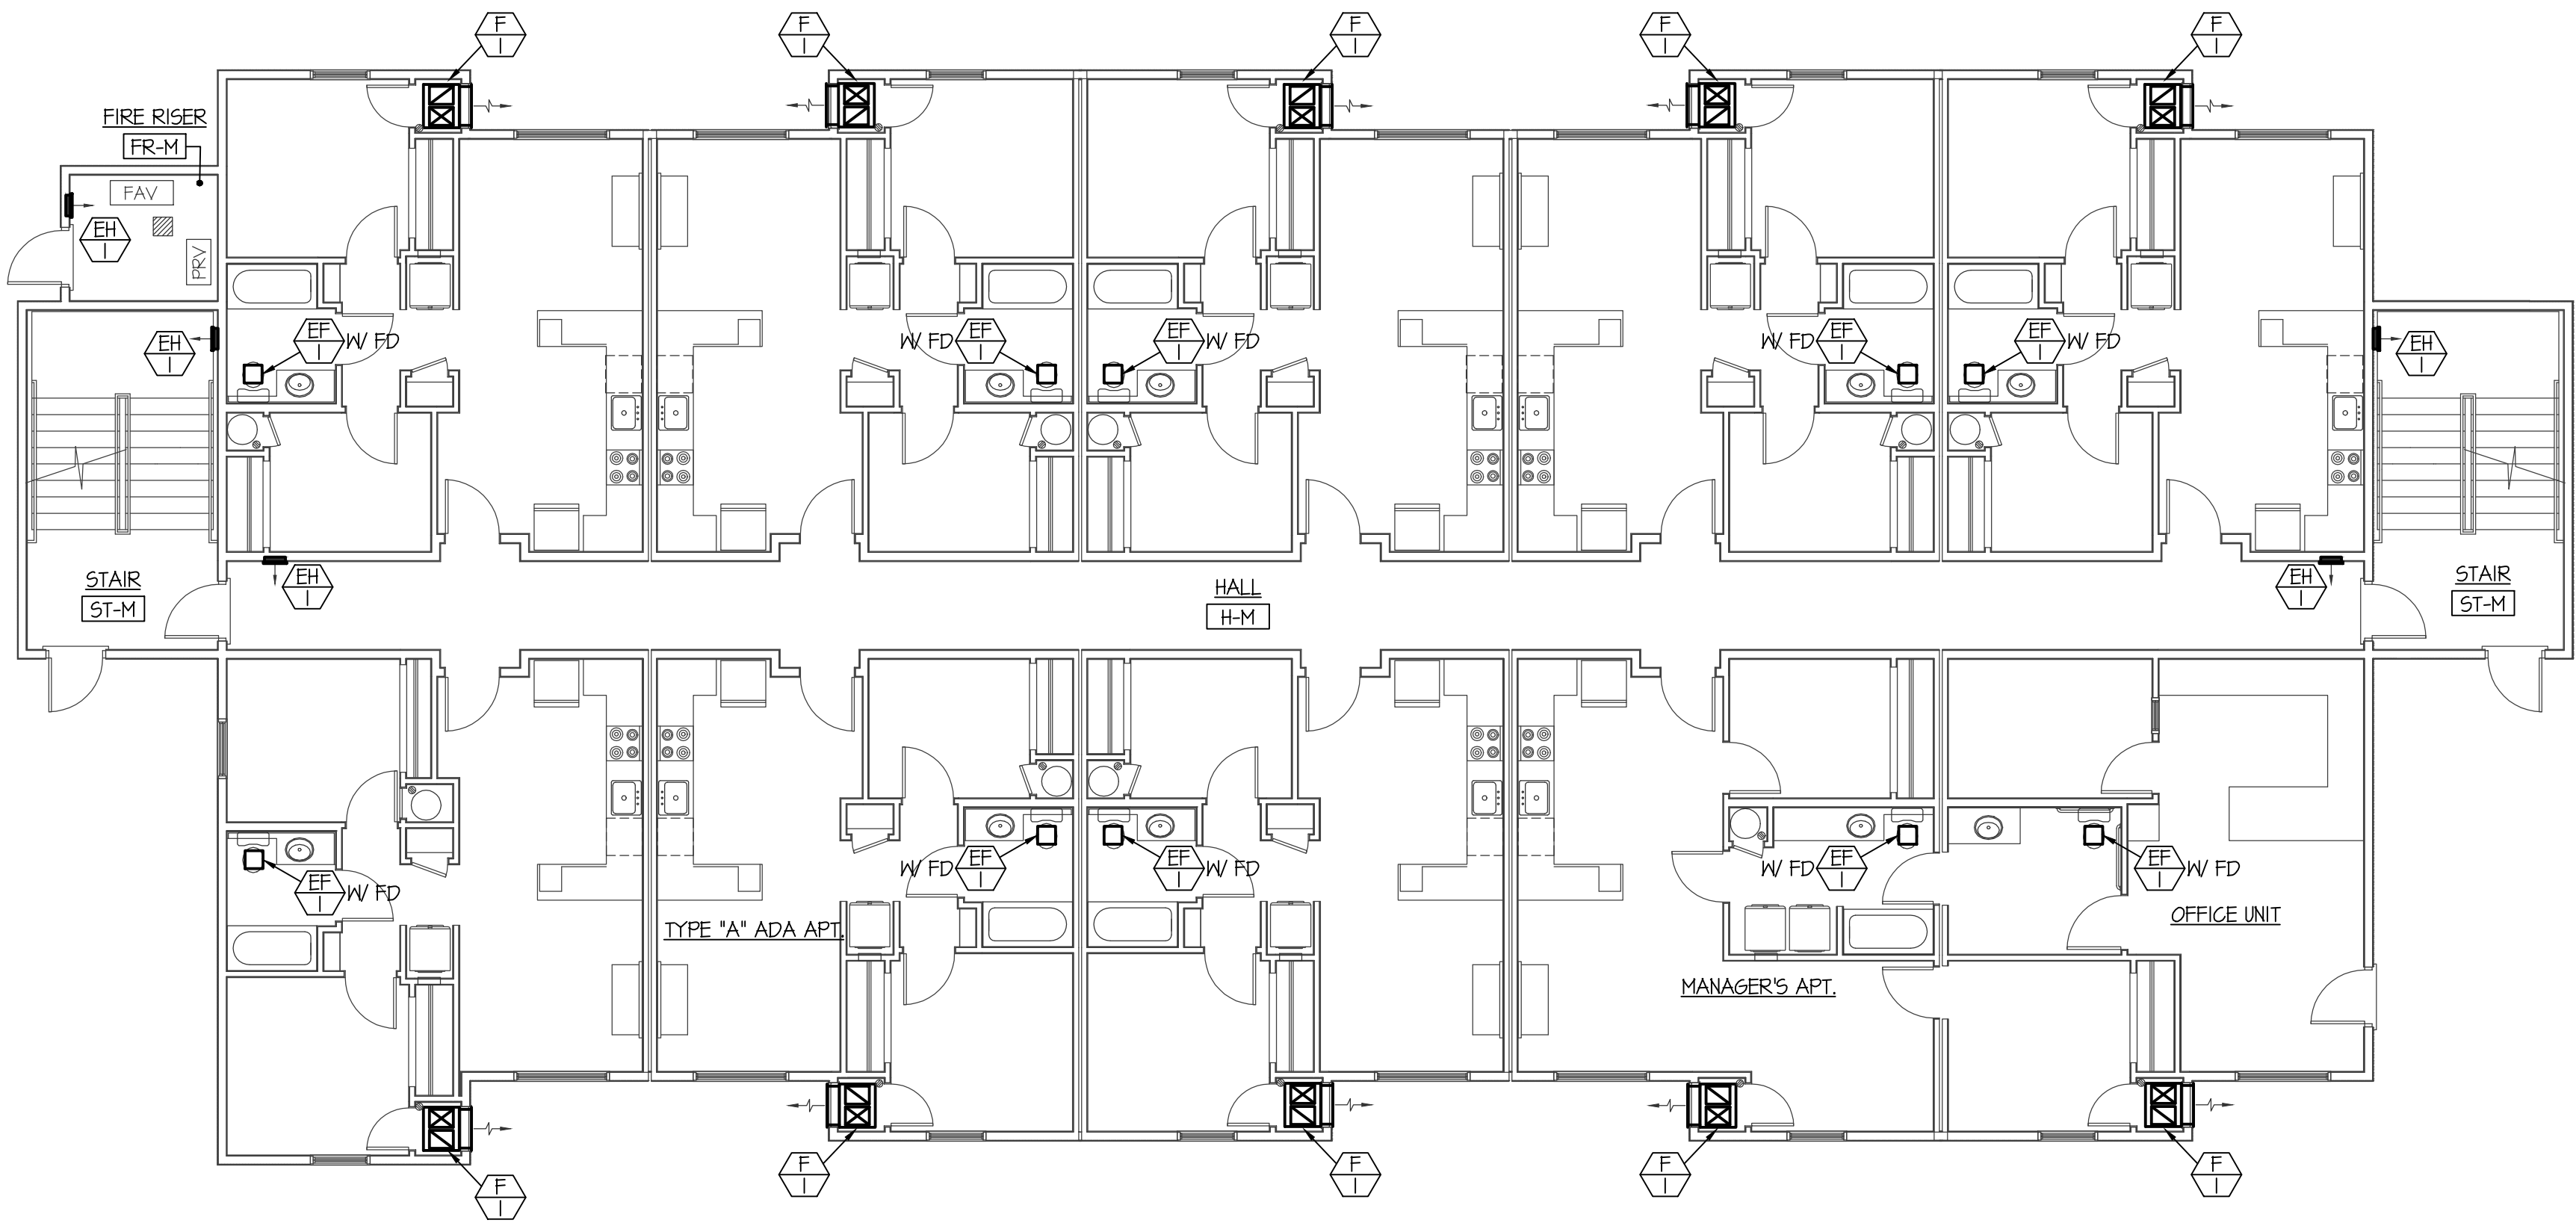

**BLDG. 1 MAIN FLOOR MECH. PLAN**  
SCALE: 1/8" = 1'-0"



PLAN NOTES:

ORIGINAL DRAWING SIGNED BY: DWAYNE C. SUDWEEKS  
DATE ORIGINAL SIGNED: Jun 14, 2017  
ORIGINAL ON FILE AT ENGINEERED SYSTEMS ASSOCIATES  
1355 EAST CENTER, POCA TELLO, IDAHO 83201

PROFESSIONAL ENGINEER  
REGISTERED  
5762  
STATE OF IDAHO  
DWAYNE C. SUDWEEKS

**Engineered Systems Associates**  
1355 EAST CENTER  
POCA TELLO, IDAHO 83201  
PHONE: (208) 233-0501  
FAX: (208) 233-0529  
EMAIL: esa@engsystems.com  
ESA JOB NUMBER: 17042

STATE OF IDAHO  
BRENT A. MCFARLAND AR-2561

**JRW & ASSOCIATES**  
1152 BOND AVENUE - Suite A REXBURG, IDAHO 83440  
WWW.JRWACOM VOICE (208) 359-2209 FAX (208) 359-2271

CONSULTANTS:

PROJECT:  
**JUNIPER SANDS APARTMENTS**  
REXBURG, IDAHO

DRAWING TITLE:  
**BLDG. 1 - BASEMENT & MAIN LEVEL MECH. PLANS**

| REVISION: |      |         |
|-----------|------|---------|
| #         | DATE | COMMENT |
|           |      |         |
|           |      |         |
|           |      |         |

|                                           |                    |
|-------------------------------------------|--------------------|
| DRAWN BY:<br>SR                           | JOB NO:<br>694     |
| CHECKED BY:<br>DCS                        | DATE:<br>JUNE 2017 |
| PLOT DATE:                                |                    |
| DRAWING NO.<br>FILE: 17042 M1.dwg<br>M.I. |                    |
| OF                                        | -                  |