



F:\17042 JUNIPER SANDS APTS\17042 M1.5.dwg Jun 19, 2017 - 3:25pm

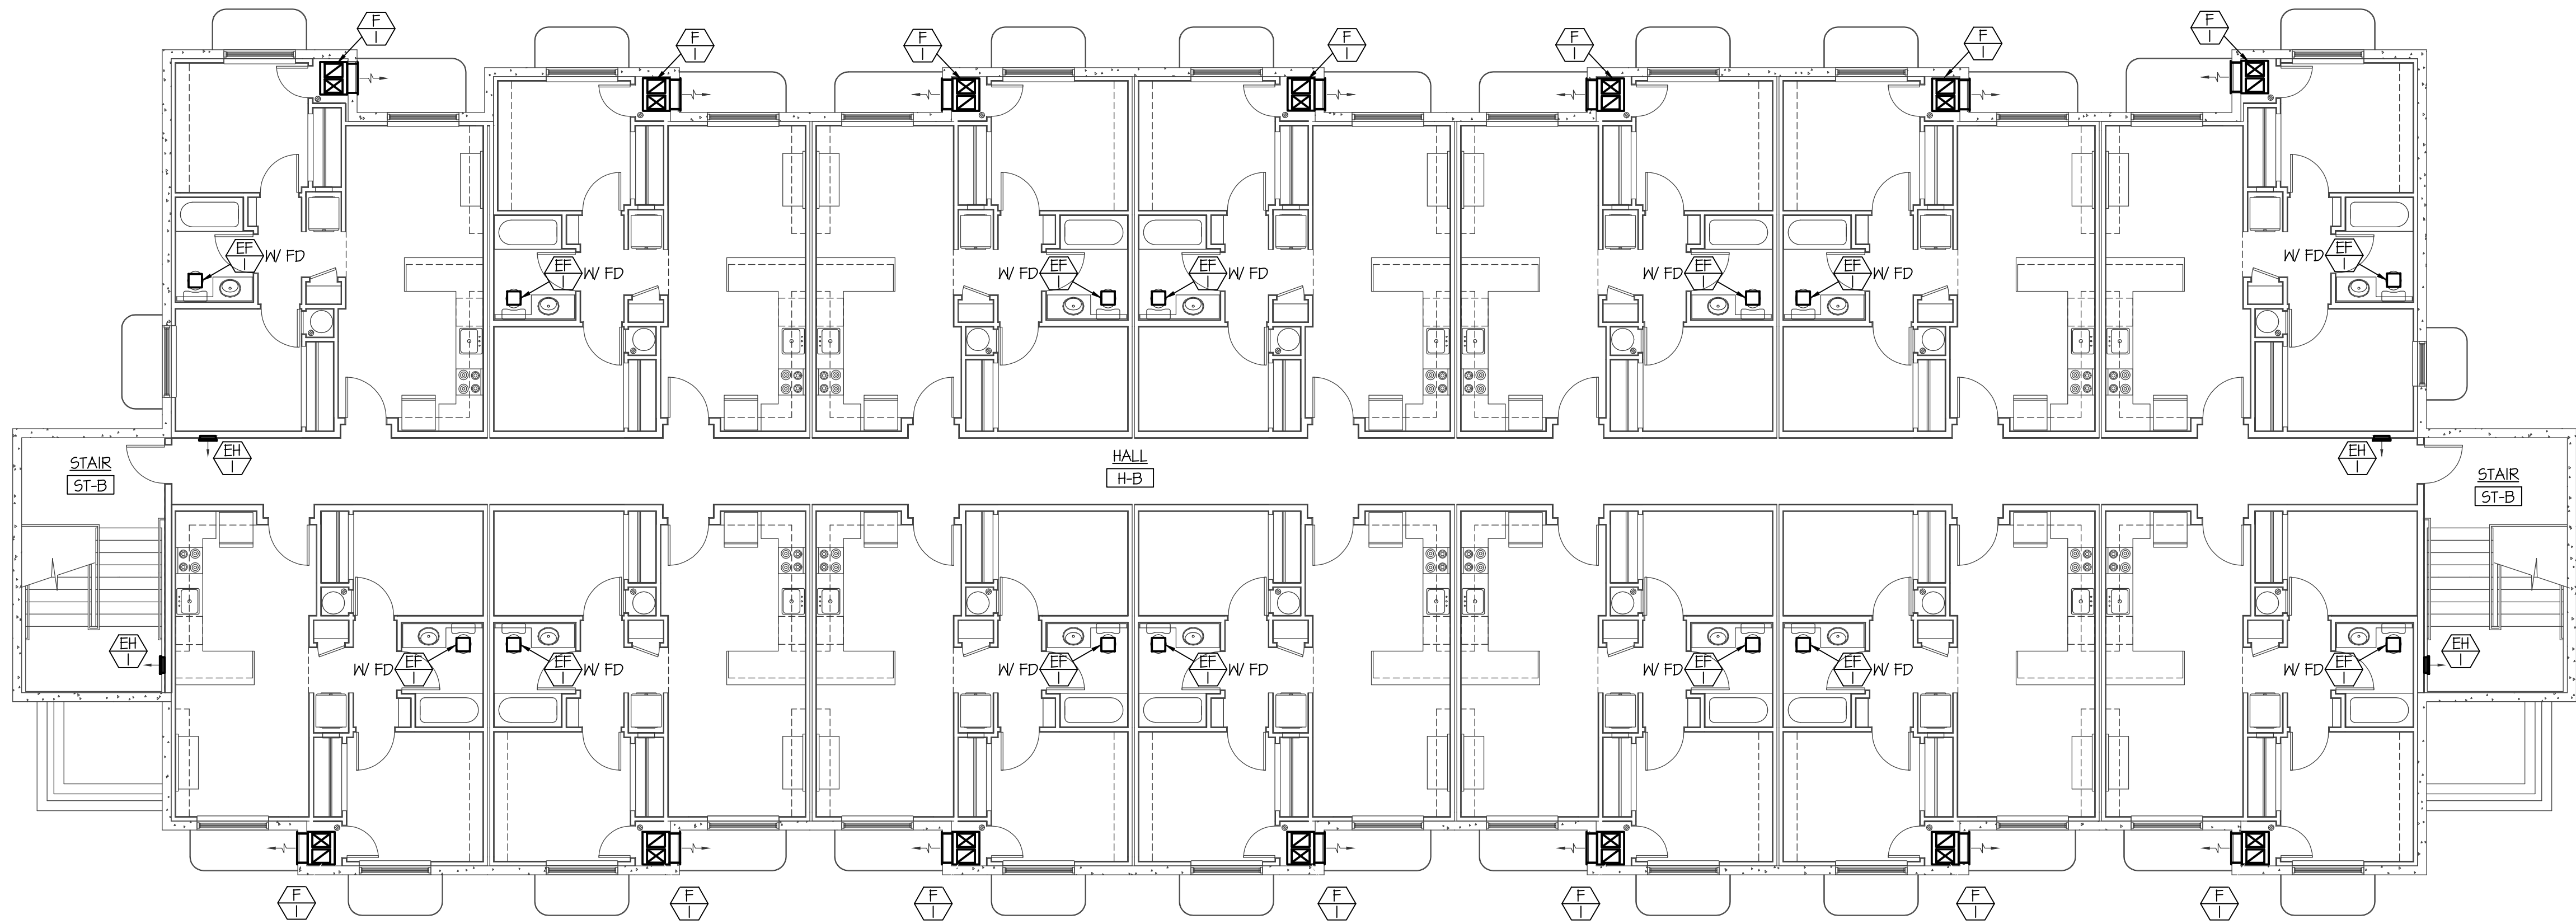



BLDG. 3 BASEMENT MECH. FLOOR PLAN
SCALE: 1/8" = 1'-0"
North

NOTE:
SEE TYPICAL APT. LARGE SCALE MECHANICAL FLOOR PLANS ON SHEET M2.0 FOR DUCTWORK AND EQUIPMENT LOCATED IN EACH APT.

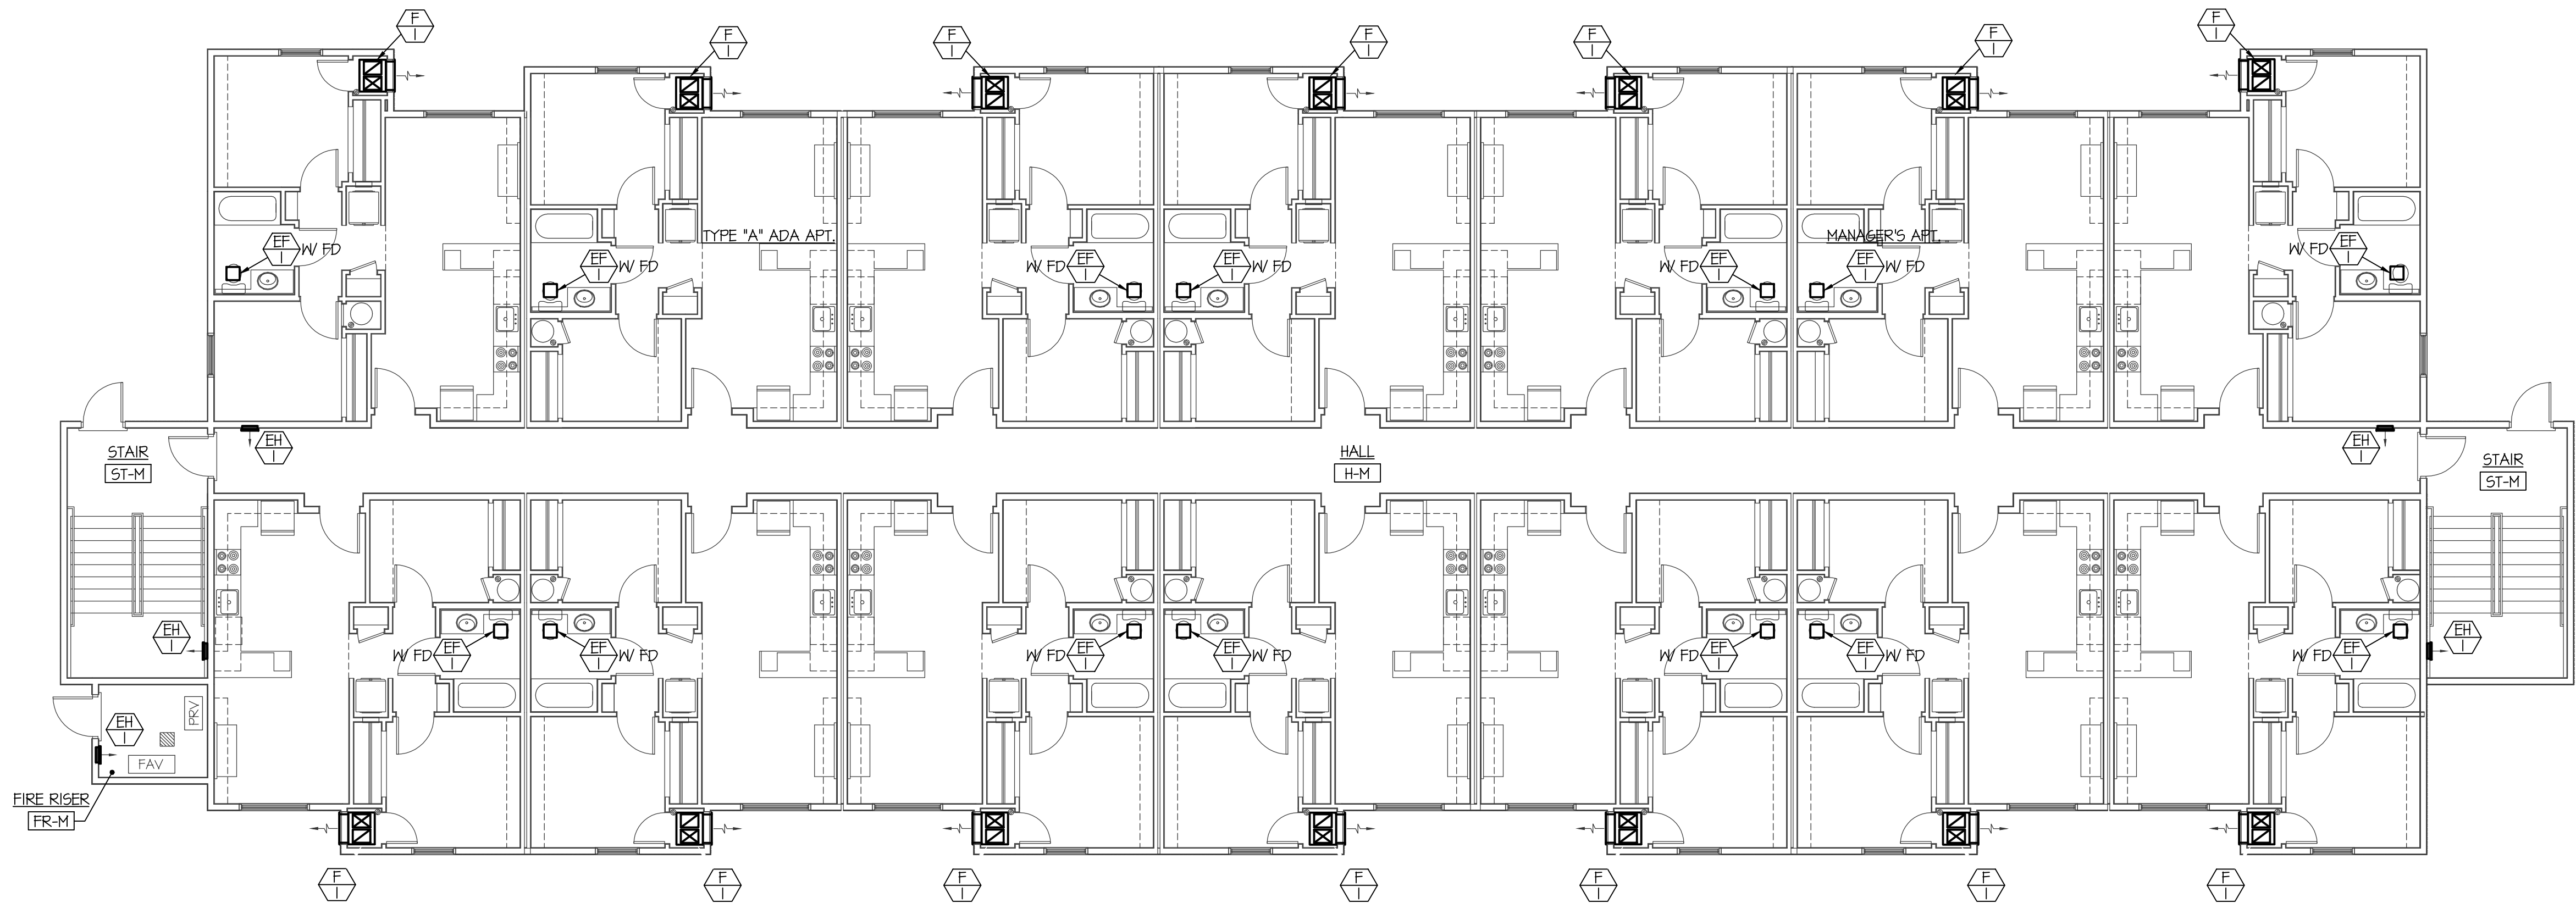

BLDG. 3 MAIN FLOOR MECH. PLAN
SCALE: 1/8" = 1'-0"
North

PLAN NOTES:

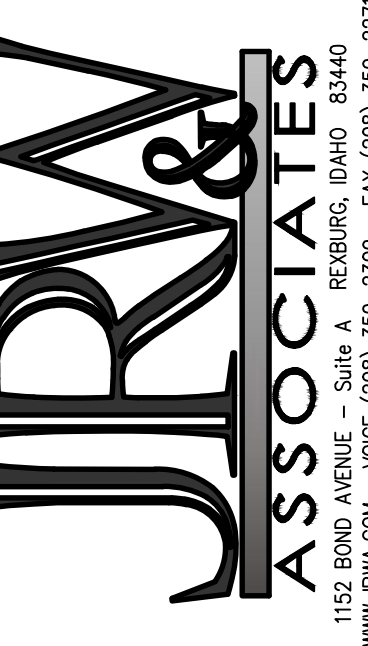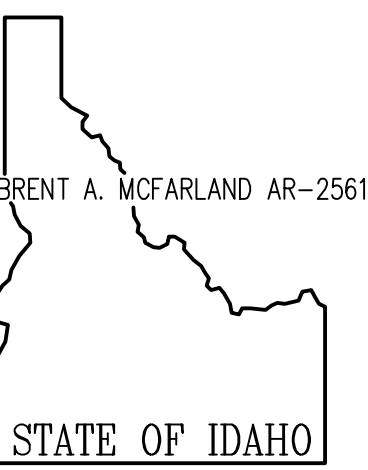

CONSULTANTS:

PROJECT: JUNIPER SANDS APARTMENTS
REDBURG, IDAHO
DRAWING TITLE: BLDG. 3 - BASEMENT & MAIN LEVEL MECH. PLANS

REVISION:		
#	DATE	COMMENT
DRAWN BY:	SR	JOB NO: 694
CHECKED BY:	DCS	DATE: JUNE 2017
PLOT DATE:		

ORIGINAL DRAWING SIGNED BY: DWAYNE C. SUDWEEKS
DATE ORIGINAL SIGNED: Jun 19, 2017
ORIGINAL ON FILE AT ENGINEERED SYSTEMS ASSOCIATES
1355 EAST CENTER, POCA TELLO, IDAHO 83201

PROFESSIONAL ENGINEER
REGISTERED
5762
STATE OF IDAHO
DWAYNE C. SUDWEEKS

Engineered Systems Associates
1355 EAST CENTER
POCA TELLO, IDAHO 83201
PHONE: (208) 233-0501
FAX: (208) 233-0529
EMAIL: eso@engsystems.com
ESA JOB NUMBER: 17042

DRAWING NO. M1.5
FILE: 17042 M1.5.dwg
OF -