



F:\17042 JUNIPER SANDS APTS\17042 M1.6.dwg Jun 19, 2017 - 3:25pm

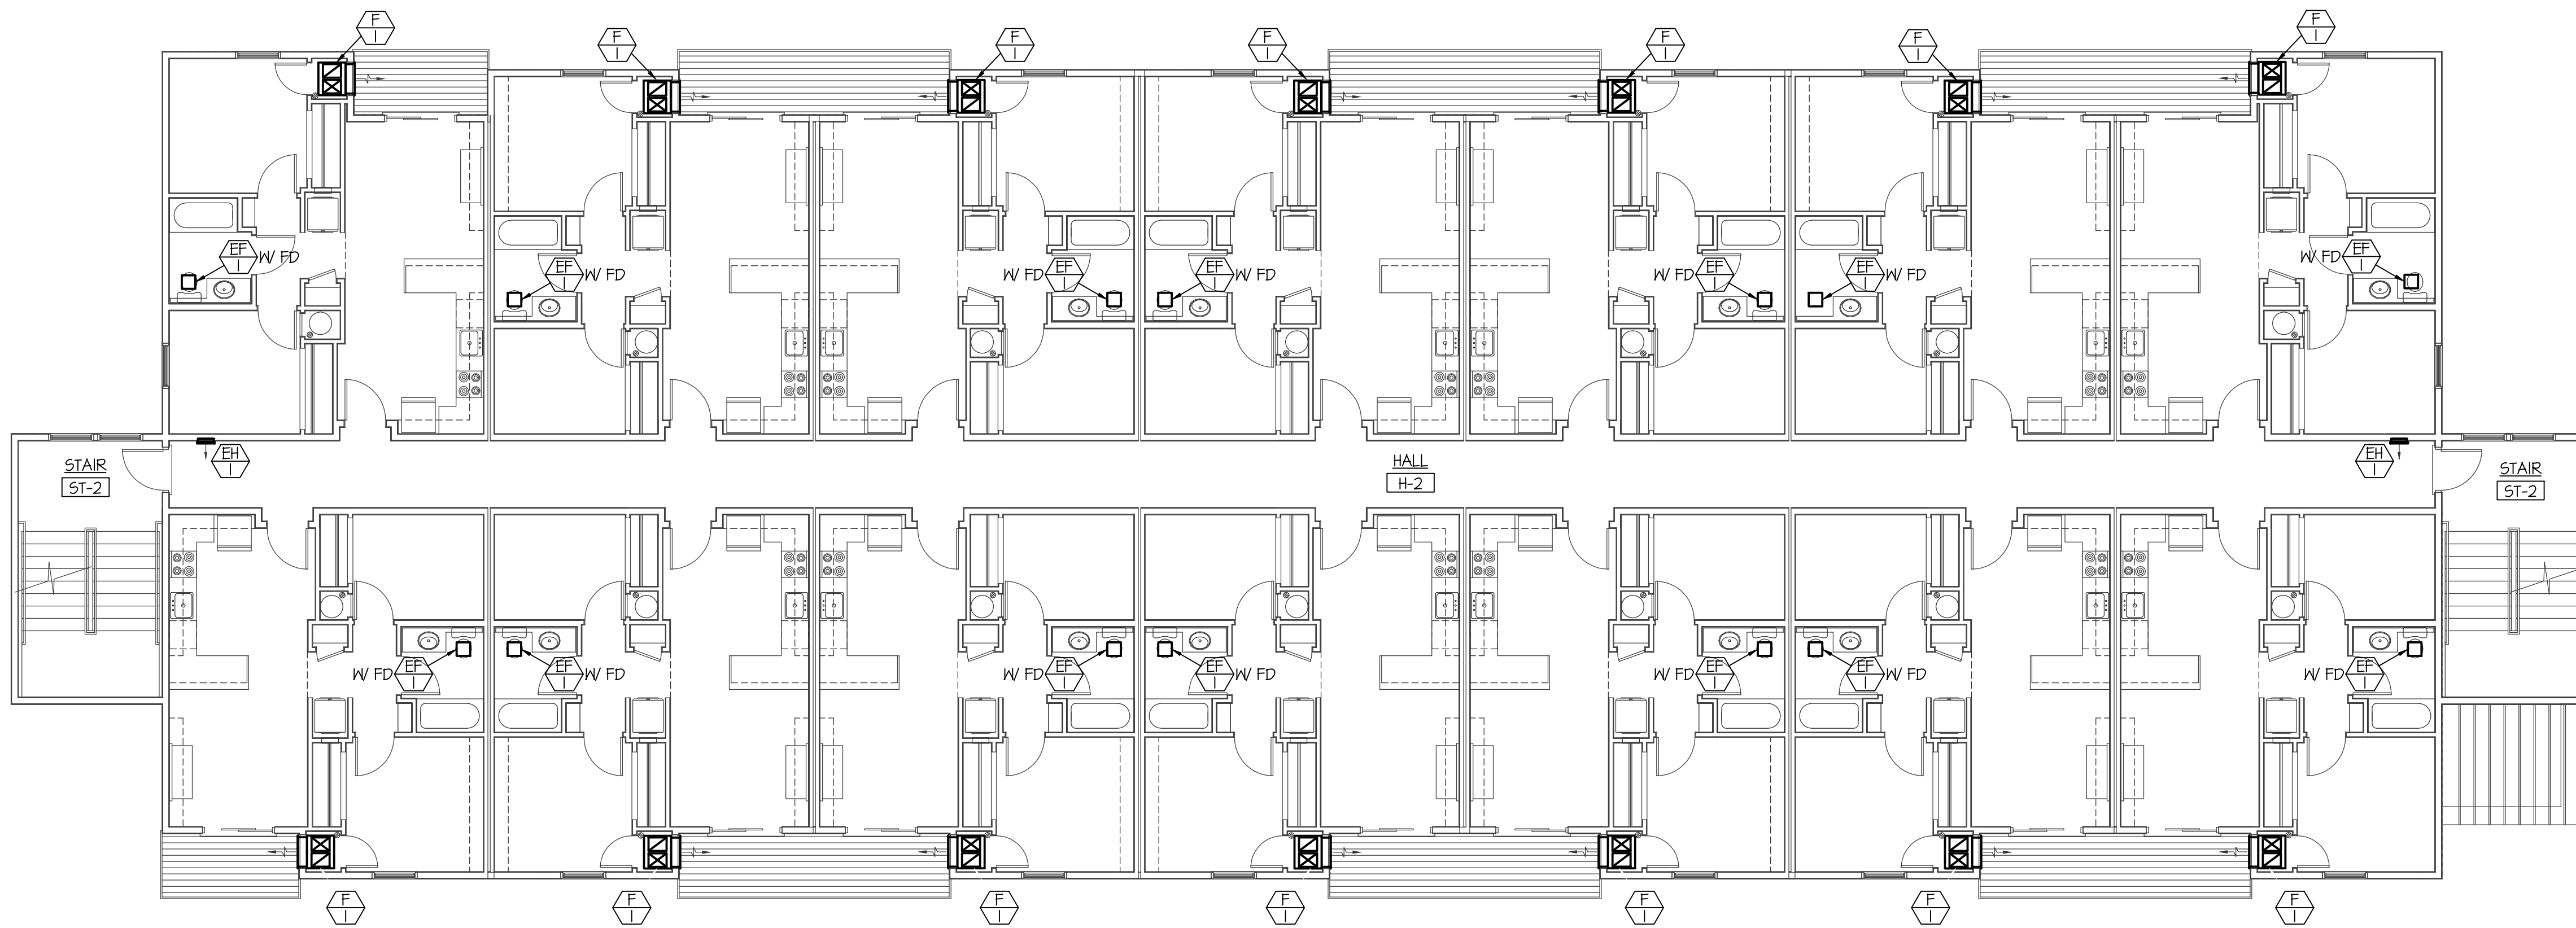



BLDG. 3 - 2ND LEVEL MECH. FLOOR PLAN
SCALE: 1/8" = 1'-0"

NOTE:
SEE TYPICAL APT. LARGE SCALE MECHANICAL FLOOR PLANS ON SHEET M2.0 FOR DUCTWORK AND EQUIPMENT LOCATED IN EACH APT.

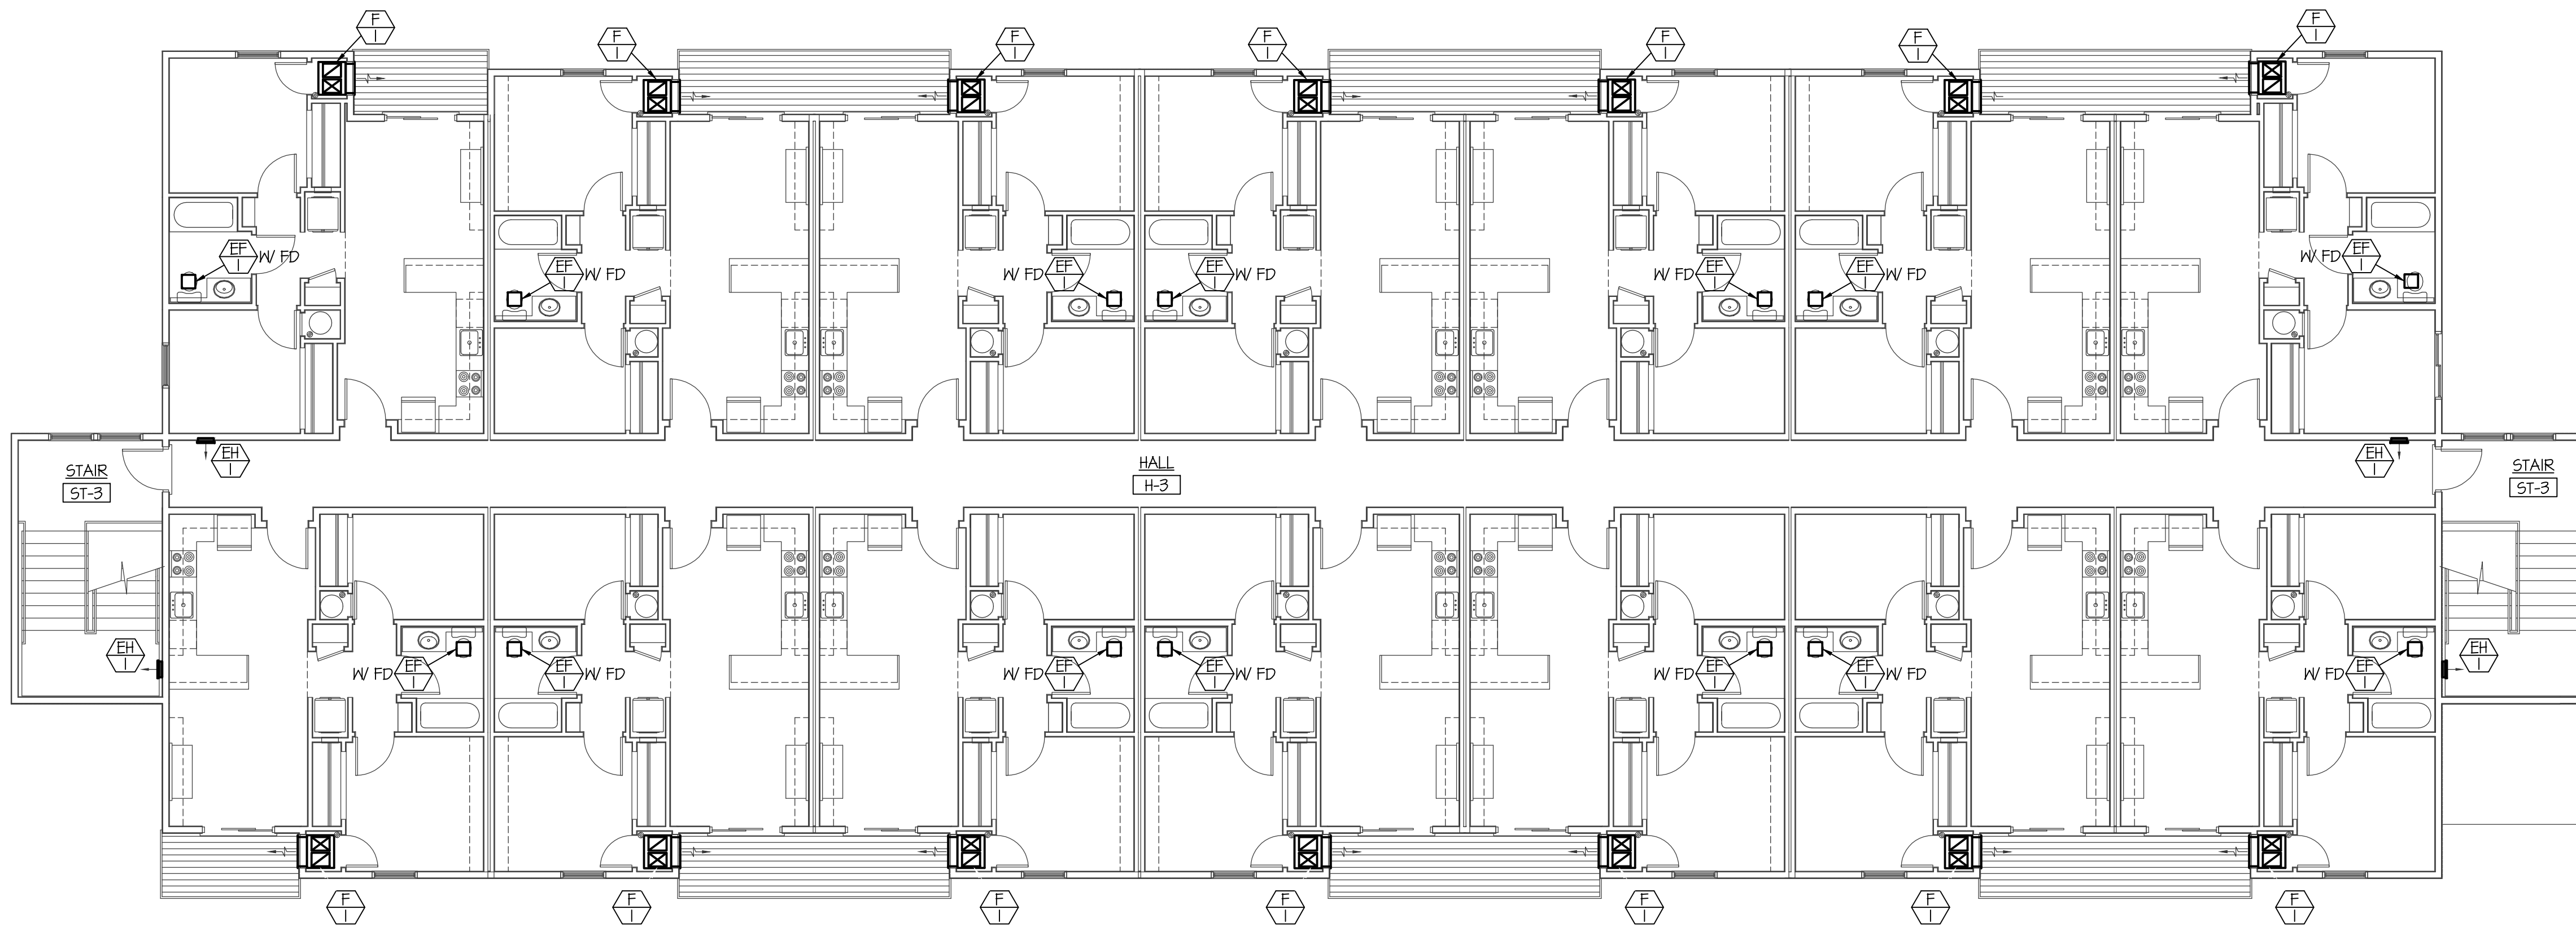

BLDG. 3 - 3RD LEVEL MECH. FLOOR PLAN
SCALE: 1/8" = 1'-0"

PLAN NOTES:

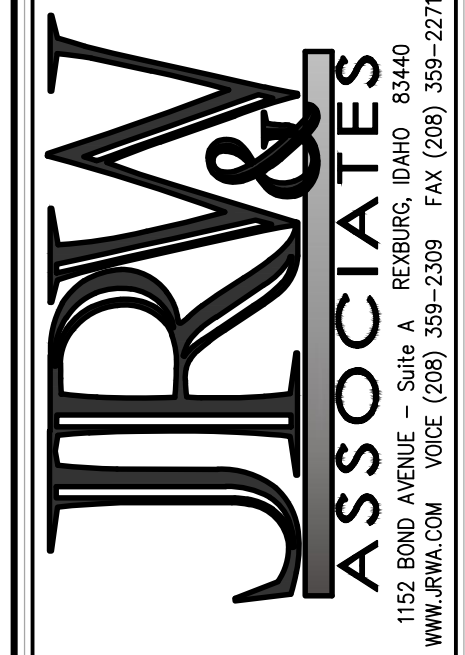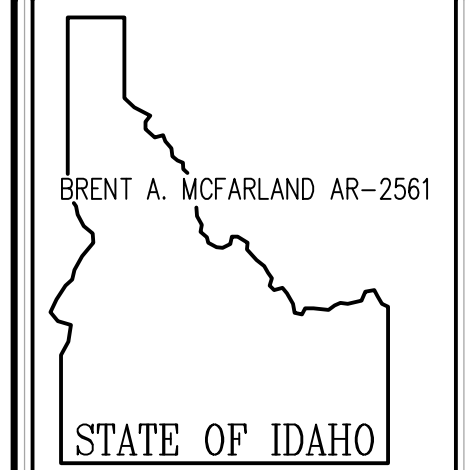

CONSULTANTS:

PROJECT: JUNIPER SANDS APARTMENTS
REXBURG, IDAHO
DRAWING TITLE: BLDG. 3 - 2ND & 3RD LEVEL MECH. PLANS

REVISION:		
#	DATE	COMMENT

ORIGINAL DRAWING SIGNED BY: DWAYNE C. SUDWEEKS
DATE ORIGINAL SIGNED: Jun 19, 2017
ORIGINAL ON FILE AT ENGINEERED SYSTEMS ASSOCIATES
1355 EAST CENTER, POCA TELLO, IDAHO 83201

PROFESSIONAL ENGINEER
REGISTERED
5762
STATE OF IDAHO
DWAYNE C. SUDWEEKS

Engineered Systems Associates
1355 EAST CENTER
POCA TELLO, IDAHO 83201
PHONE: (208) 233-0501
FAX: (208) 233-0529
EMAIL: eso@engsystems.com
ESA JOB NUMBER: 17042

PLOT DATE:
DRAWING NO. M1.6
FILE: 17042 M1.6.dwg
OF -