



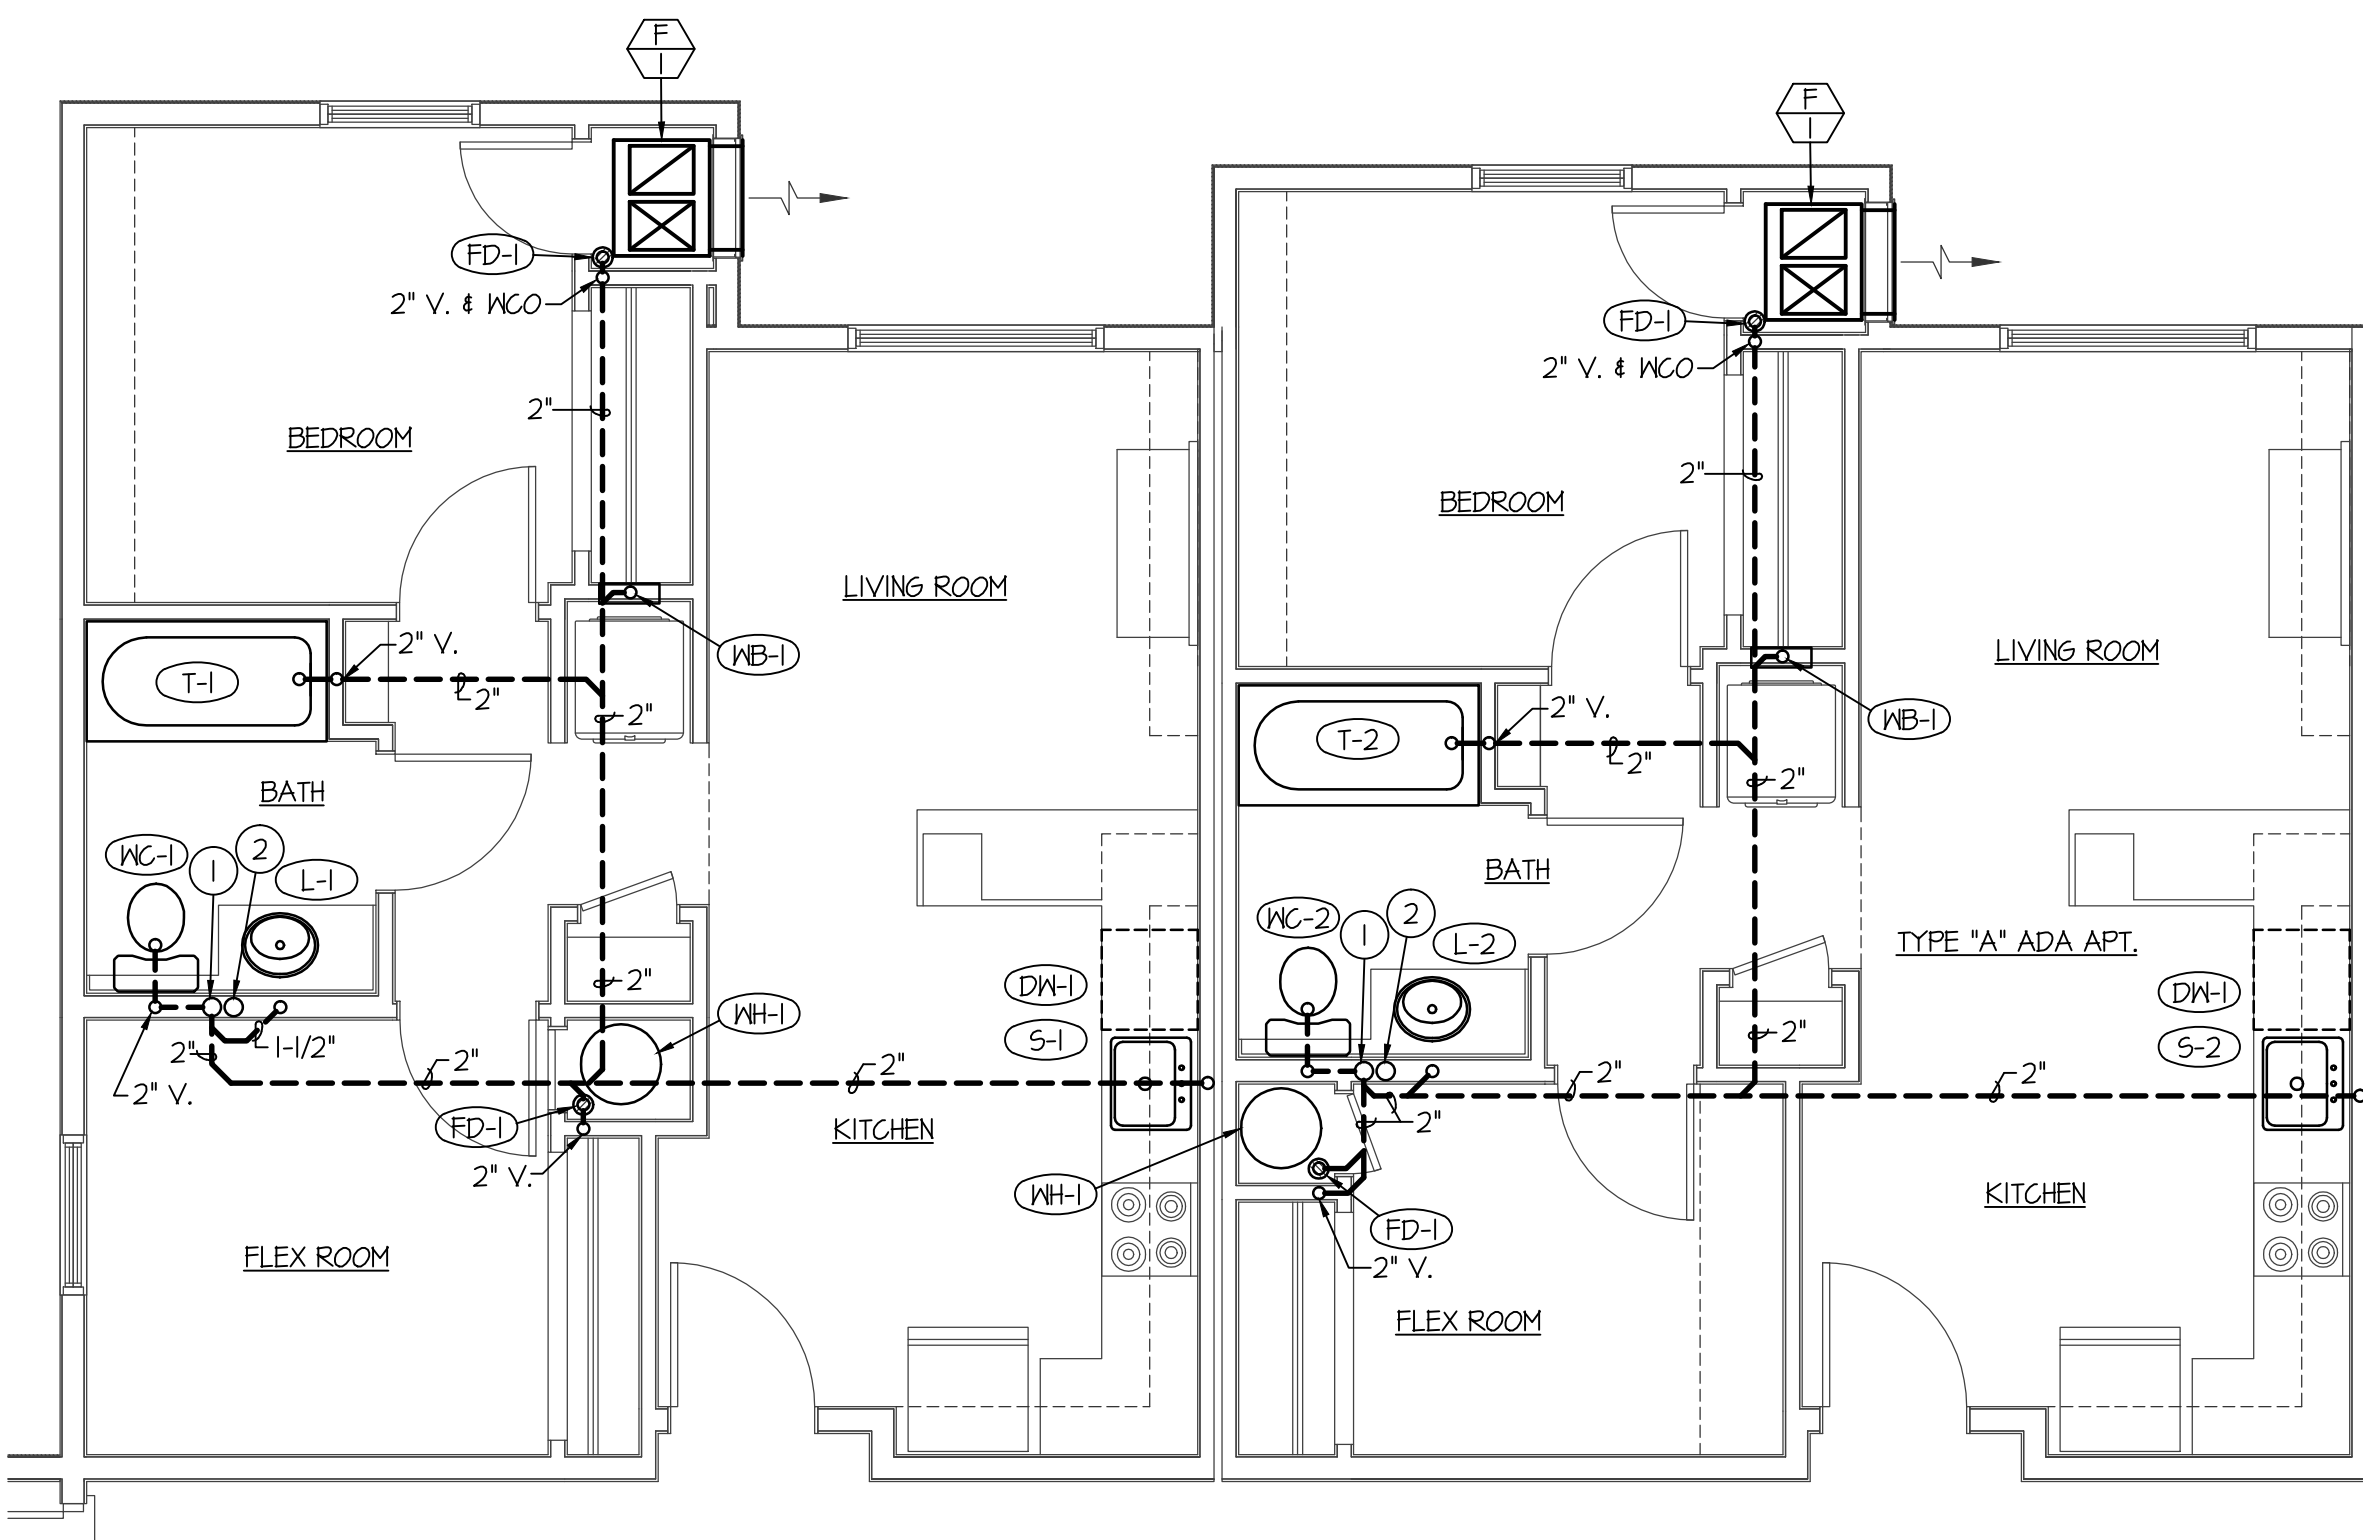



**TYPICAL MAIN LEVEL APTS.
WASTE PIPING FLOOR PLANS**

SCALE: 1/4" = 1'-0"

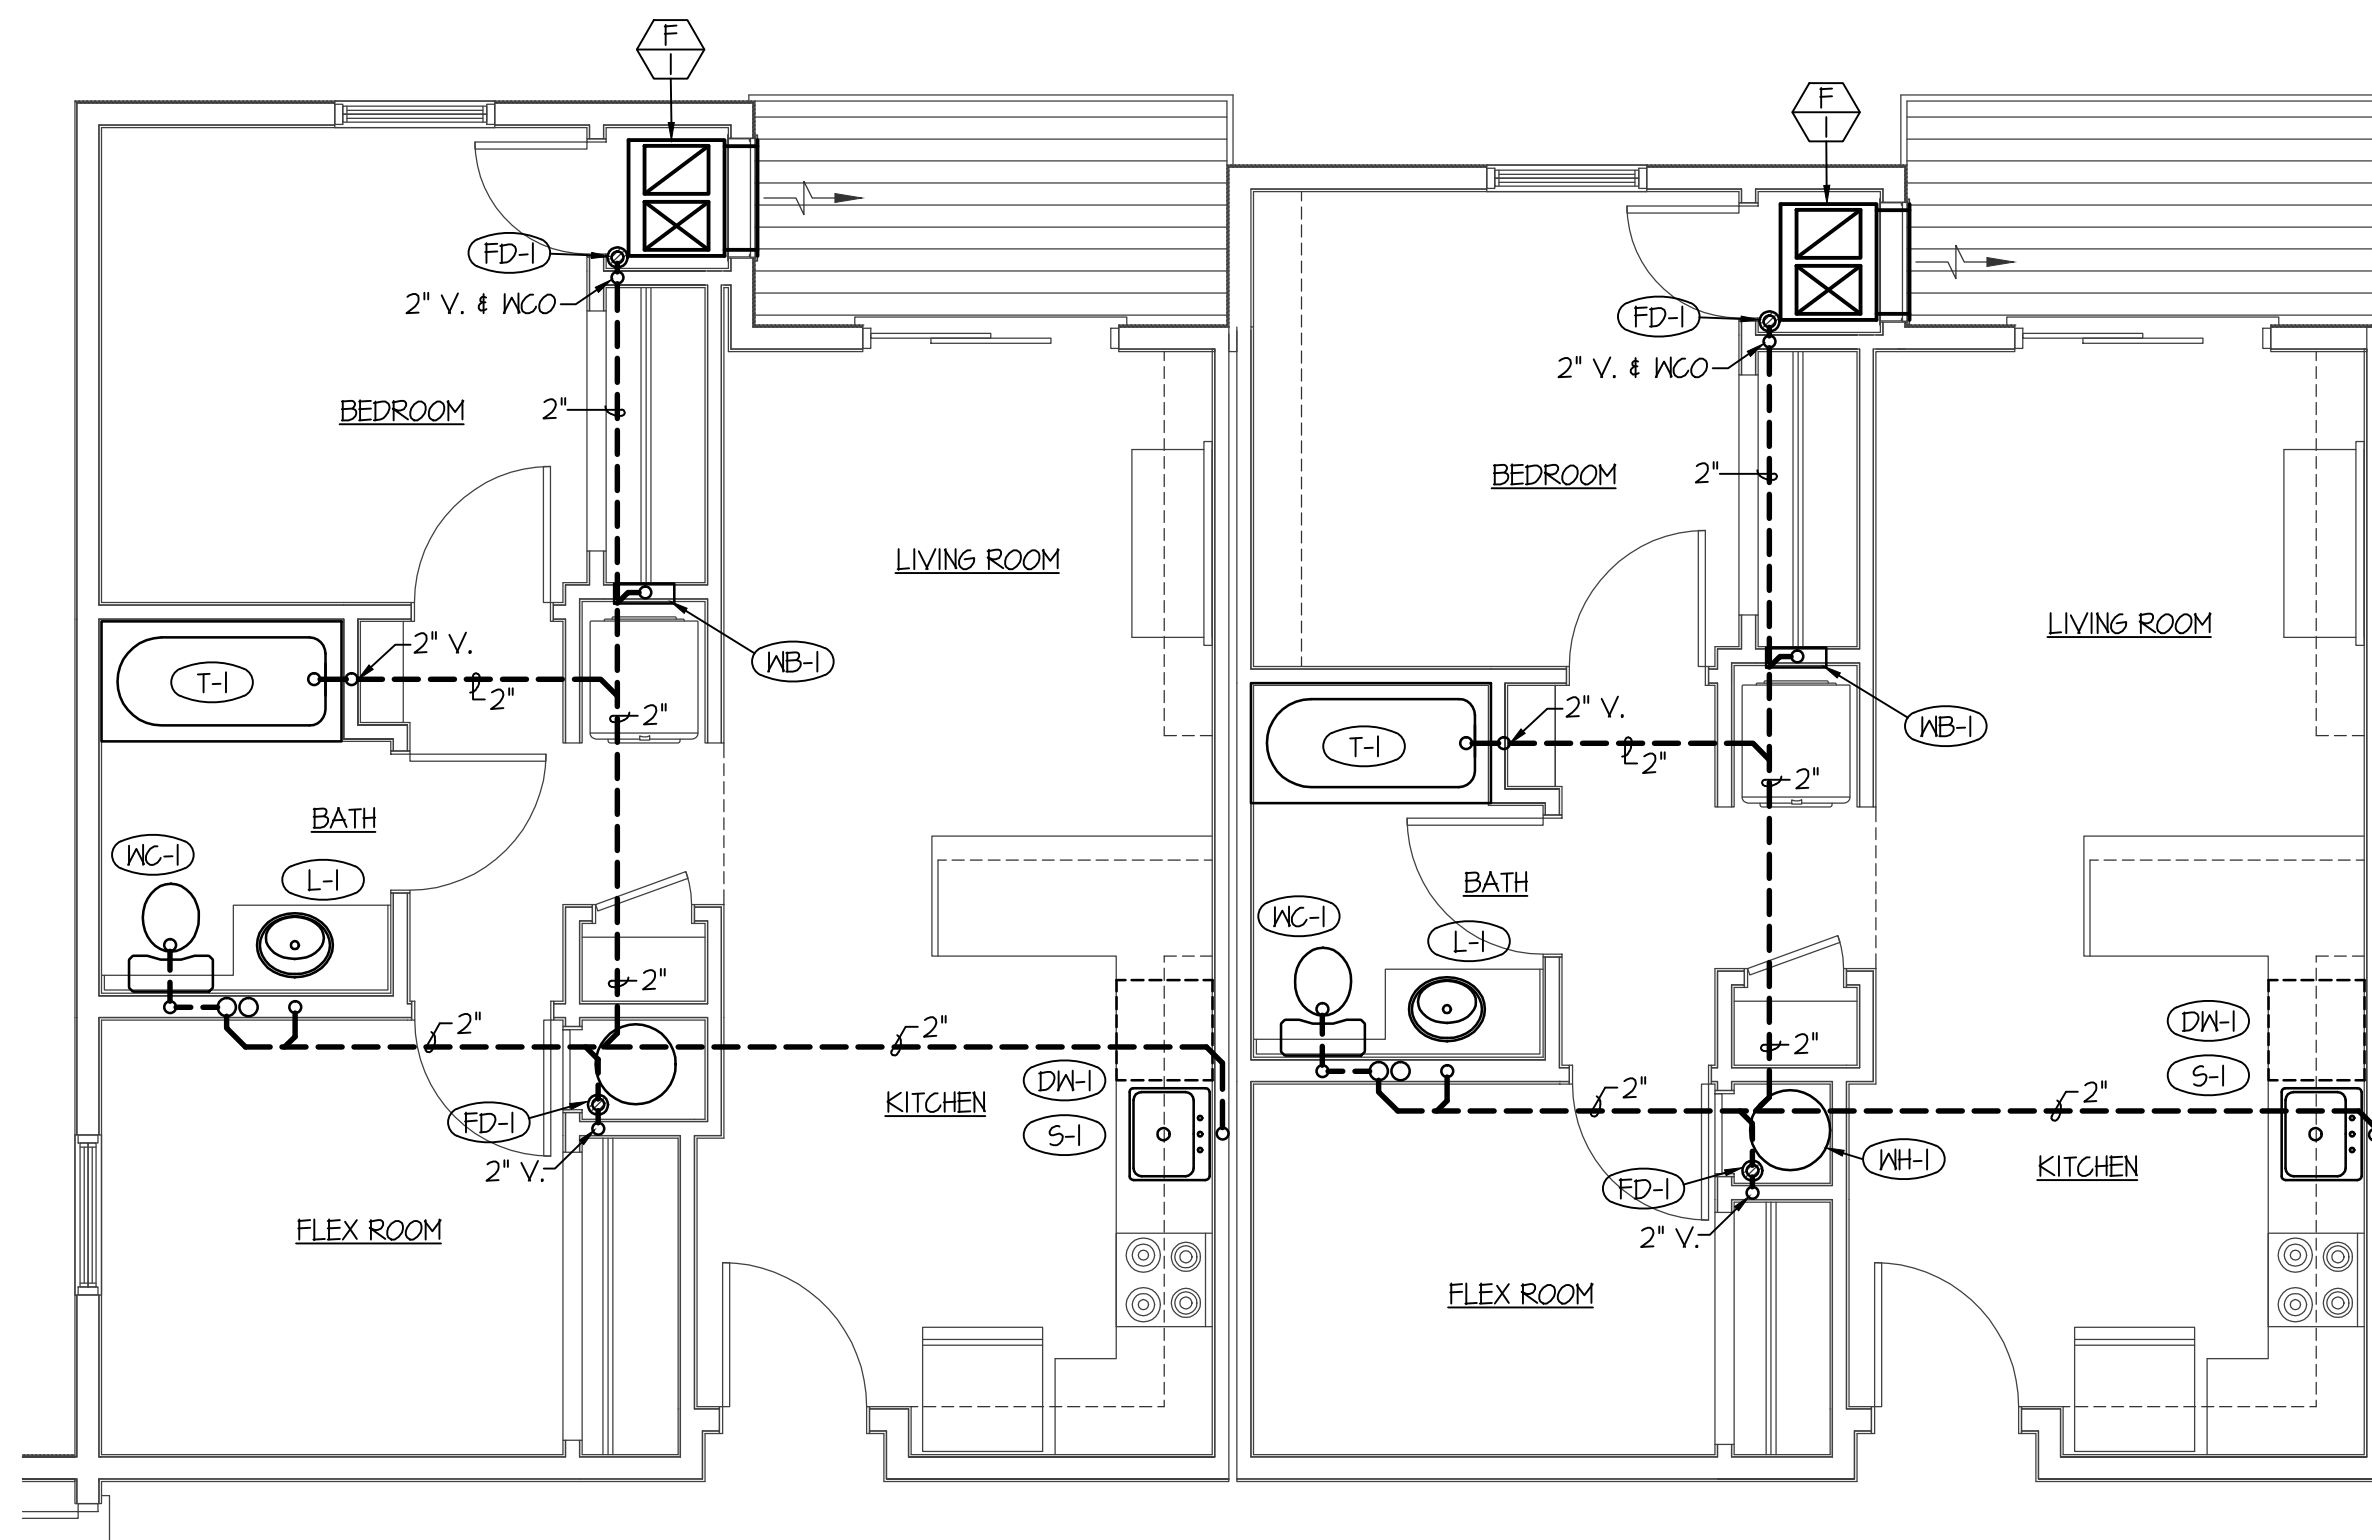


**TYPICAL ONE & TWO BED RM. APTS
WASTE PIPING FLOOR PLANS**

SCALE: 1/4" = 1'-0"

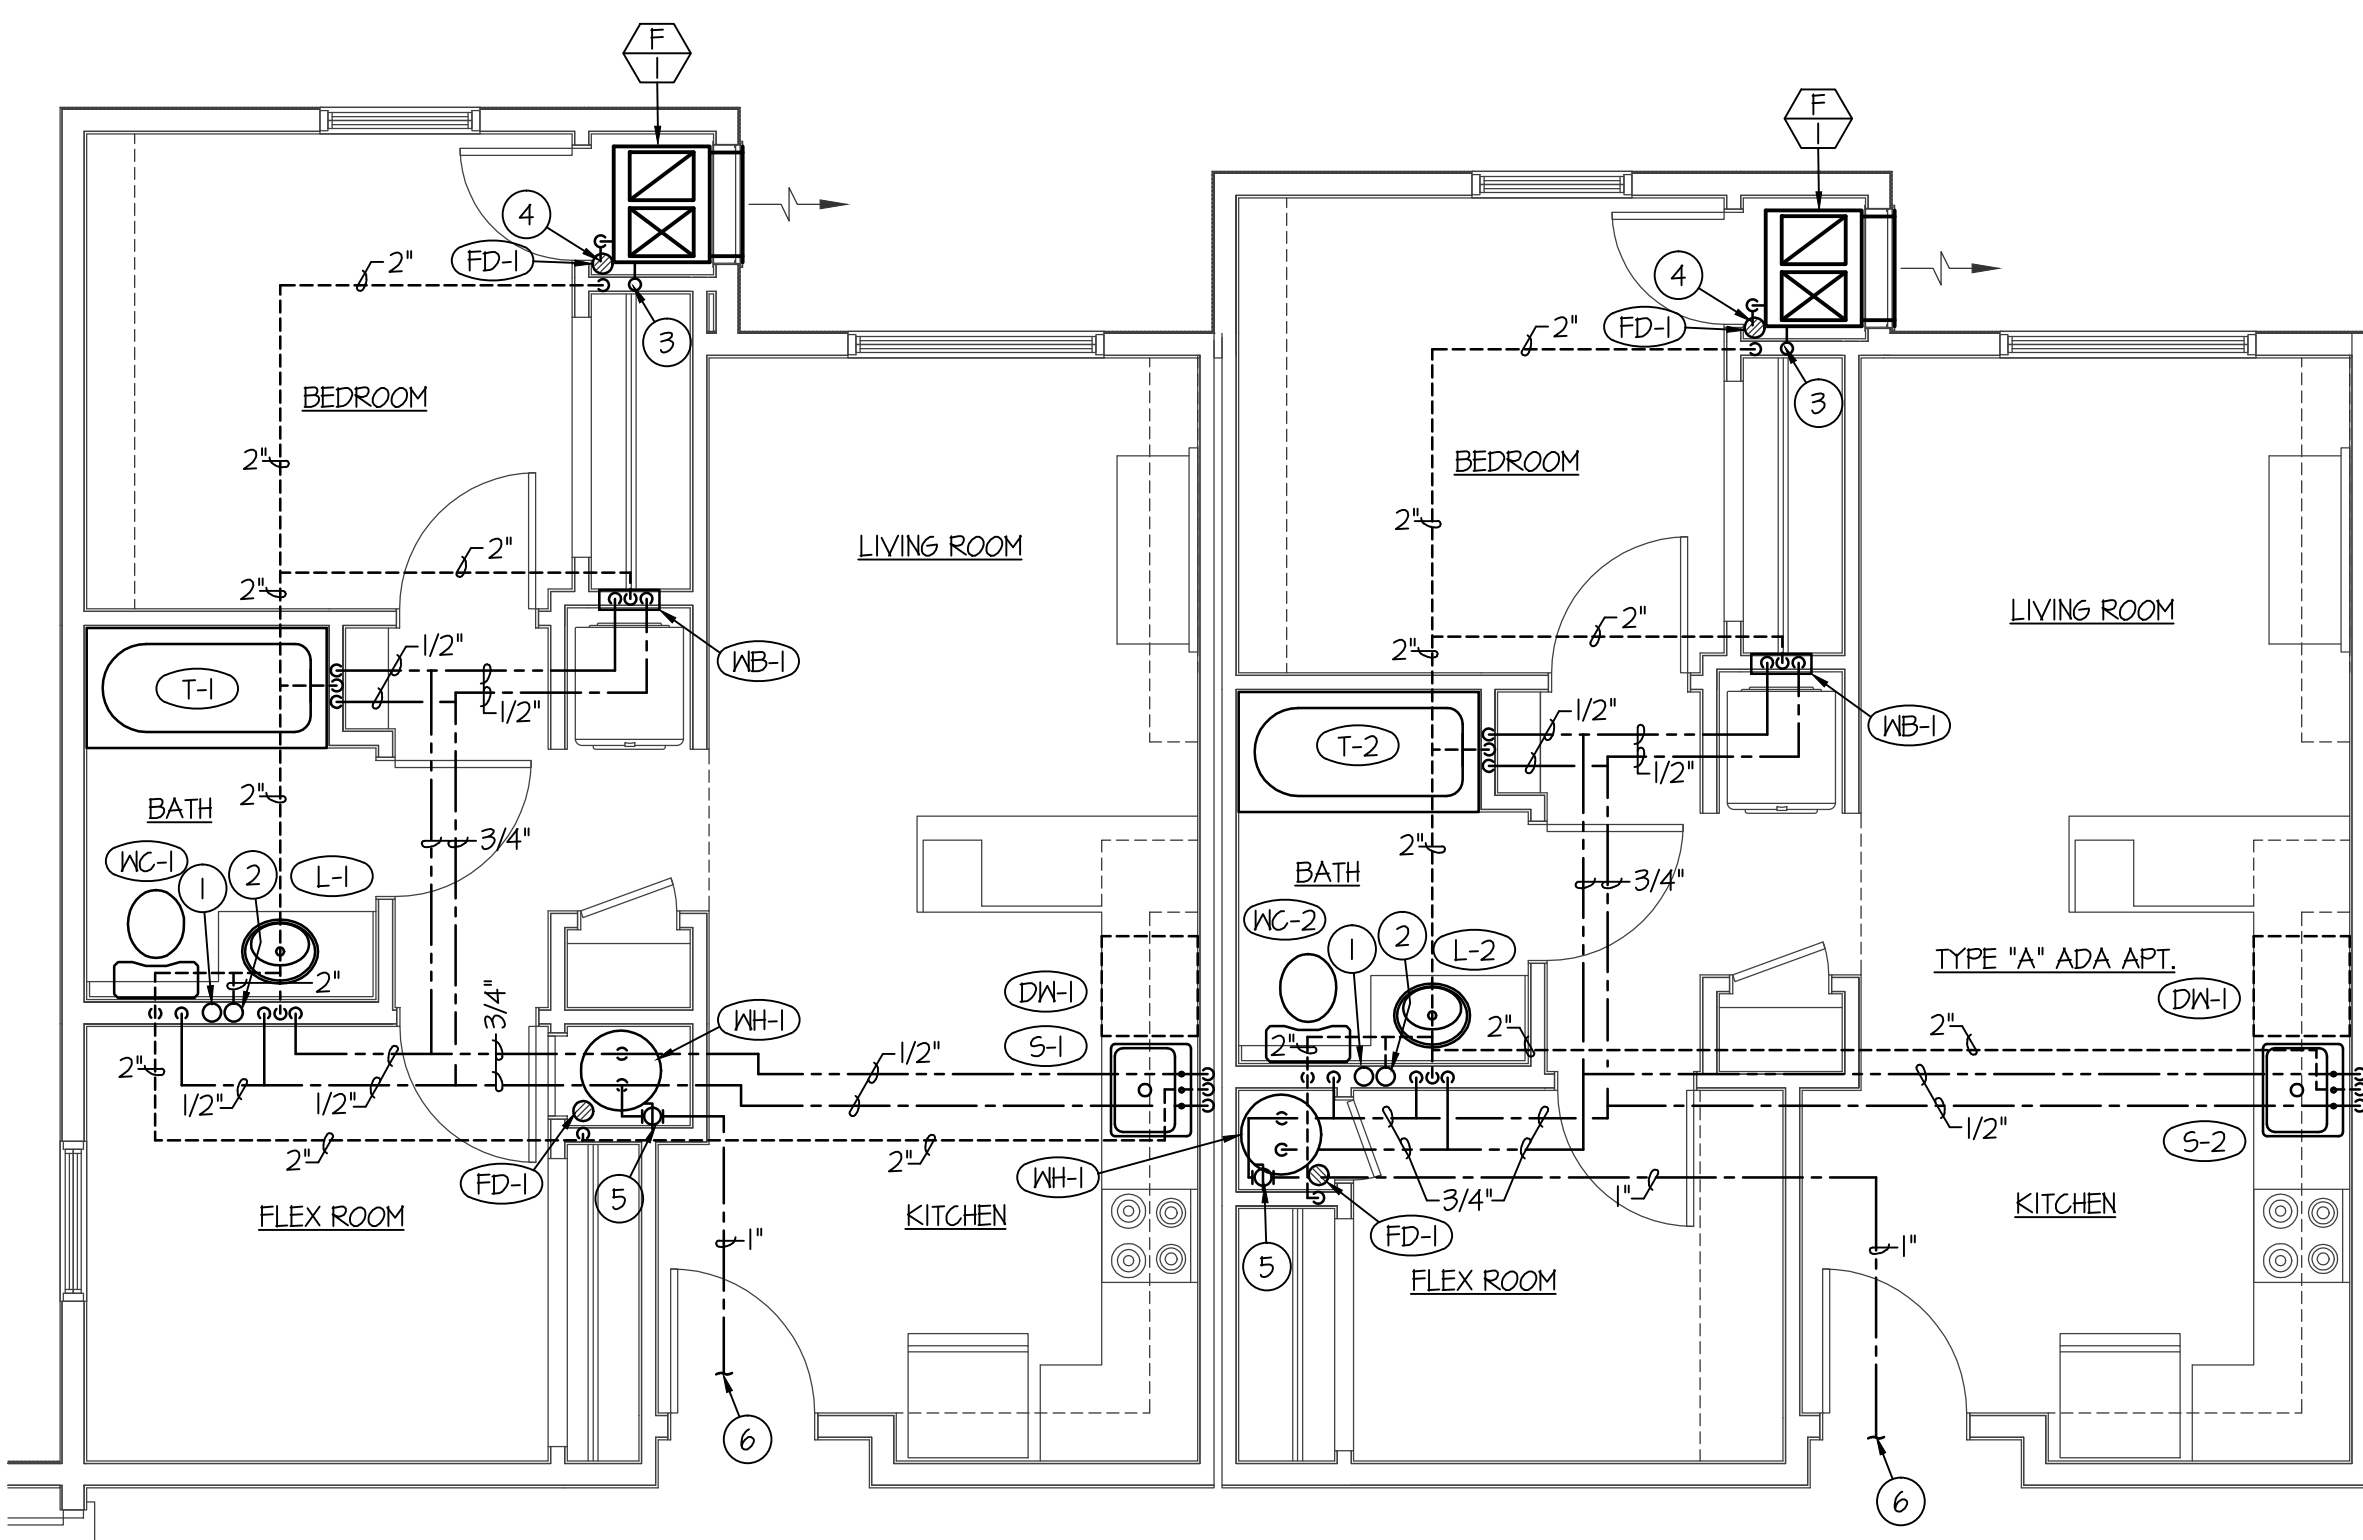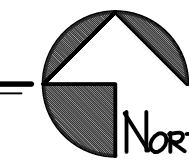


**TYPICAL MAIN LEVEL APTS. WATER,
GAS AND VENT PIPING FLOOR PLANS**

SCALE: 1/4" = 1'-0"

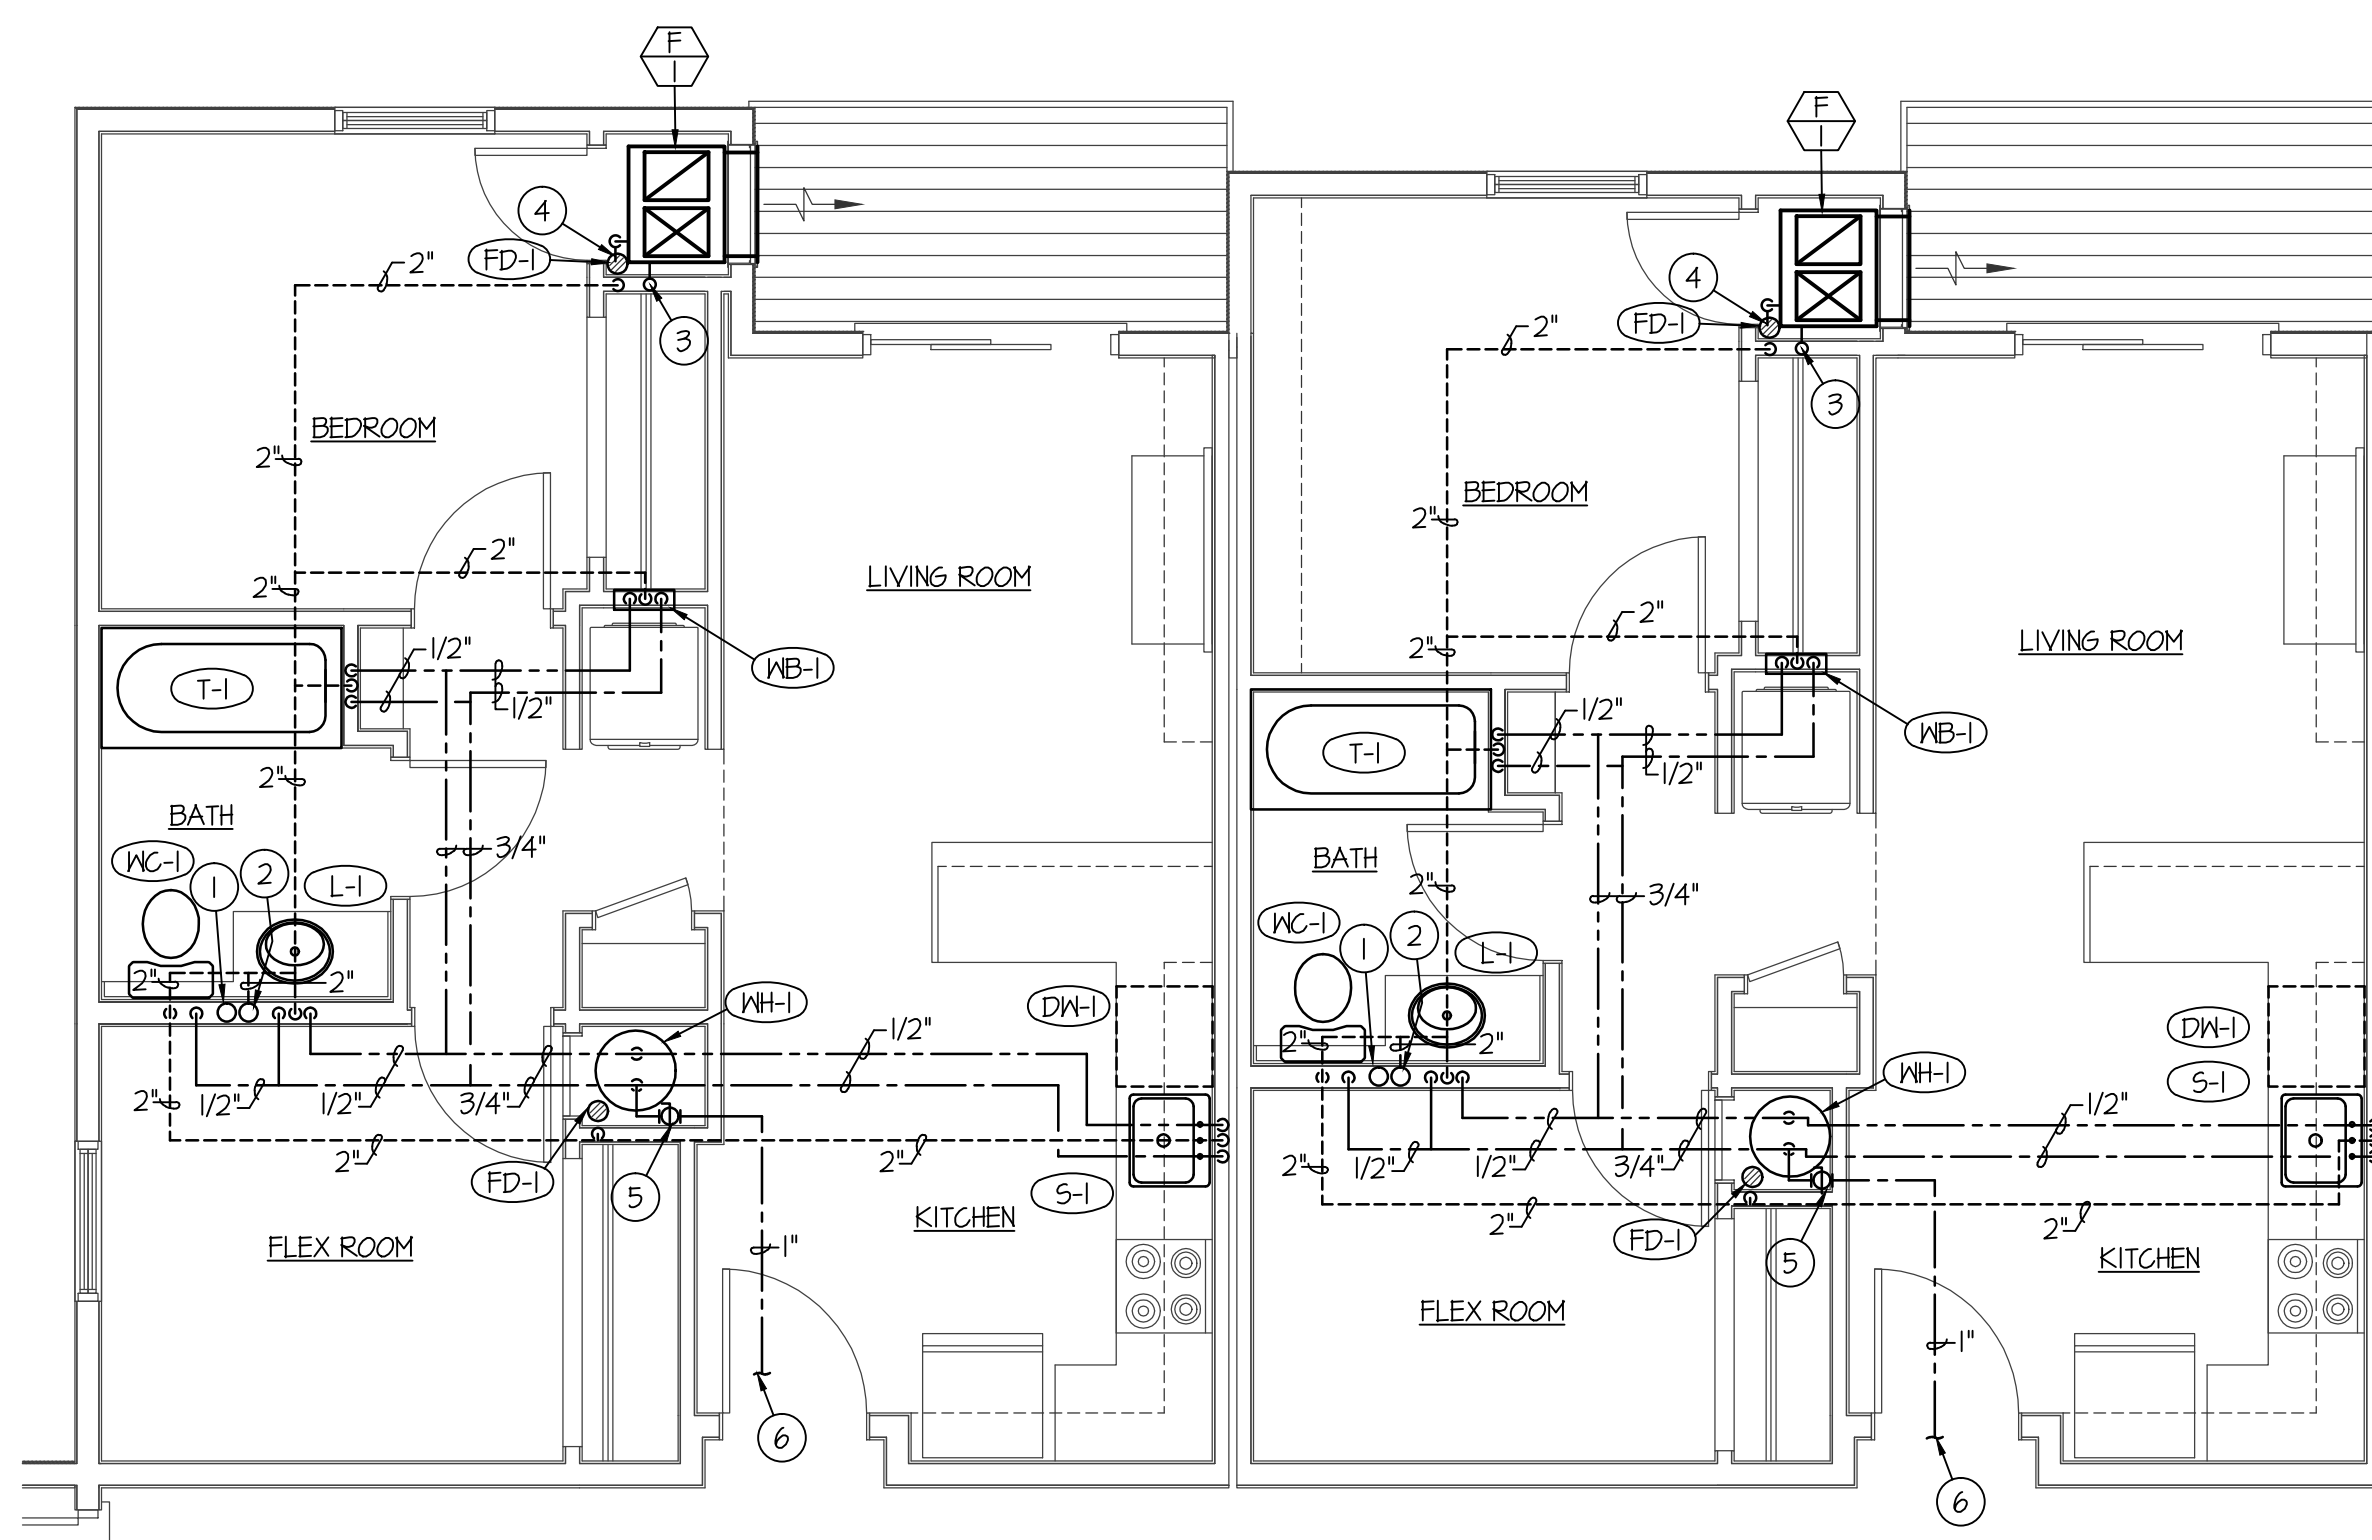

**TYPICAL ONE & TWO BED RM. APTS WATER,
GAS AND VENT PIPING FLOOR PLANS**

SCALE: 1/4" = 1'-0"

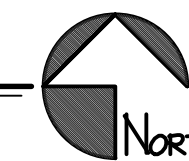

PLAN NOTES:

- 1 4" WASTE STACK IN WALL SERVING 3 LEVELS OF FIXTURES. SEE BASEMENT PLUMBING PLAN FOR WASTE PIPING UNDERSLAB.
- 2 4" VENT STACK IN WALL SERVING 4 LEVELS OF FIXTURES.
- 3 DROP 3/4" GAS LINE DOWN TO SERVE FURNACE AND CONNECT. INSTALL SHUT-OFF VALVE, DIRT LEG AND FLEXIBLE CONNECTION AT UNIT. SEE DETAIL ON SHEET P3.0.
- 4 RUN 3/4" CONDENSATE DRAIN LINE FROM FURNACE F-1 TO FLOOR DRAIN LOCATED IN MECH. ROOM. TERMINATE WITH DOWNTURNED 90° ELBOW AND AIR GAP.
- 5 INSTALL 1" BALL TYPE SHUT-OFF VALVE ON CW MAIN SERVING EACH APT. IN ACCESSIBLE LOCATION ABOVE WATER HEATER IN CLOSET.
- 6 SEE PLUMBING FLOOR PLANS FOR CONTINUATION OF WATER PIPING.

BRENT A. MCFARLAND AR-2561

STATE OF IDAHO

JRW & ASSOCIATES

1152 BOND AVENUE - SUITE A REIDBURG, IDAHO 83440
WWW.JRWAA.COM VOICE (208) 359-2271 FAX (208) 359-2271

CONSULTANTS:


PROJECT: JUNIPER SANDS APARTMENTS REIDBURG, IDAHO

DRAWING TITLE: TYPICAL APT. LARGE SCALE PLUMBING PLANS

REVISION:

#	DATE	COMMENT
1	06-14-2017	DCS
2	06-14-2017	DCS
3	06-14-2017	DCS
4	06-14-2017	DCS
5	06-14-2017	DCS
6	06-14-2017	DCS

ORIGINAL DRAWING SIGNED BY: DWAYNE C. SUDNEEKS
DATE ORIGINAL SIGNED: Jun 14, 2017
ORIGINAL ON FILE AT ENGINEERED SYSTEMS ASSOCIATES
1355 EAST CENTER, POCA TELLO, IDAHO 83201

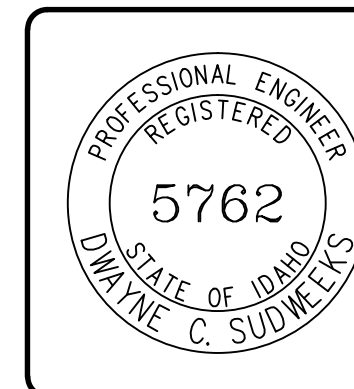

Engineered Systems Associates

1355 EAST CENTER
POCA TELLO, IDAHO 83201
PHONE: (208) 233-0501
FAX: (208) 233-0529
EMAIL: esa@engsystems.com
ESA JOB NUMBER: 17042

DRAWING NO.	FILE: 17042 P2.0.dwg
P2.0	
OF	-