


CHILLER REPLACEMENT FOR:
LIBERAL ARTS BUILDING
IDAHO STATE UNIVERSITY
POCATELLO, IDAHO
DPW PROJECT #18223

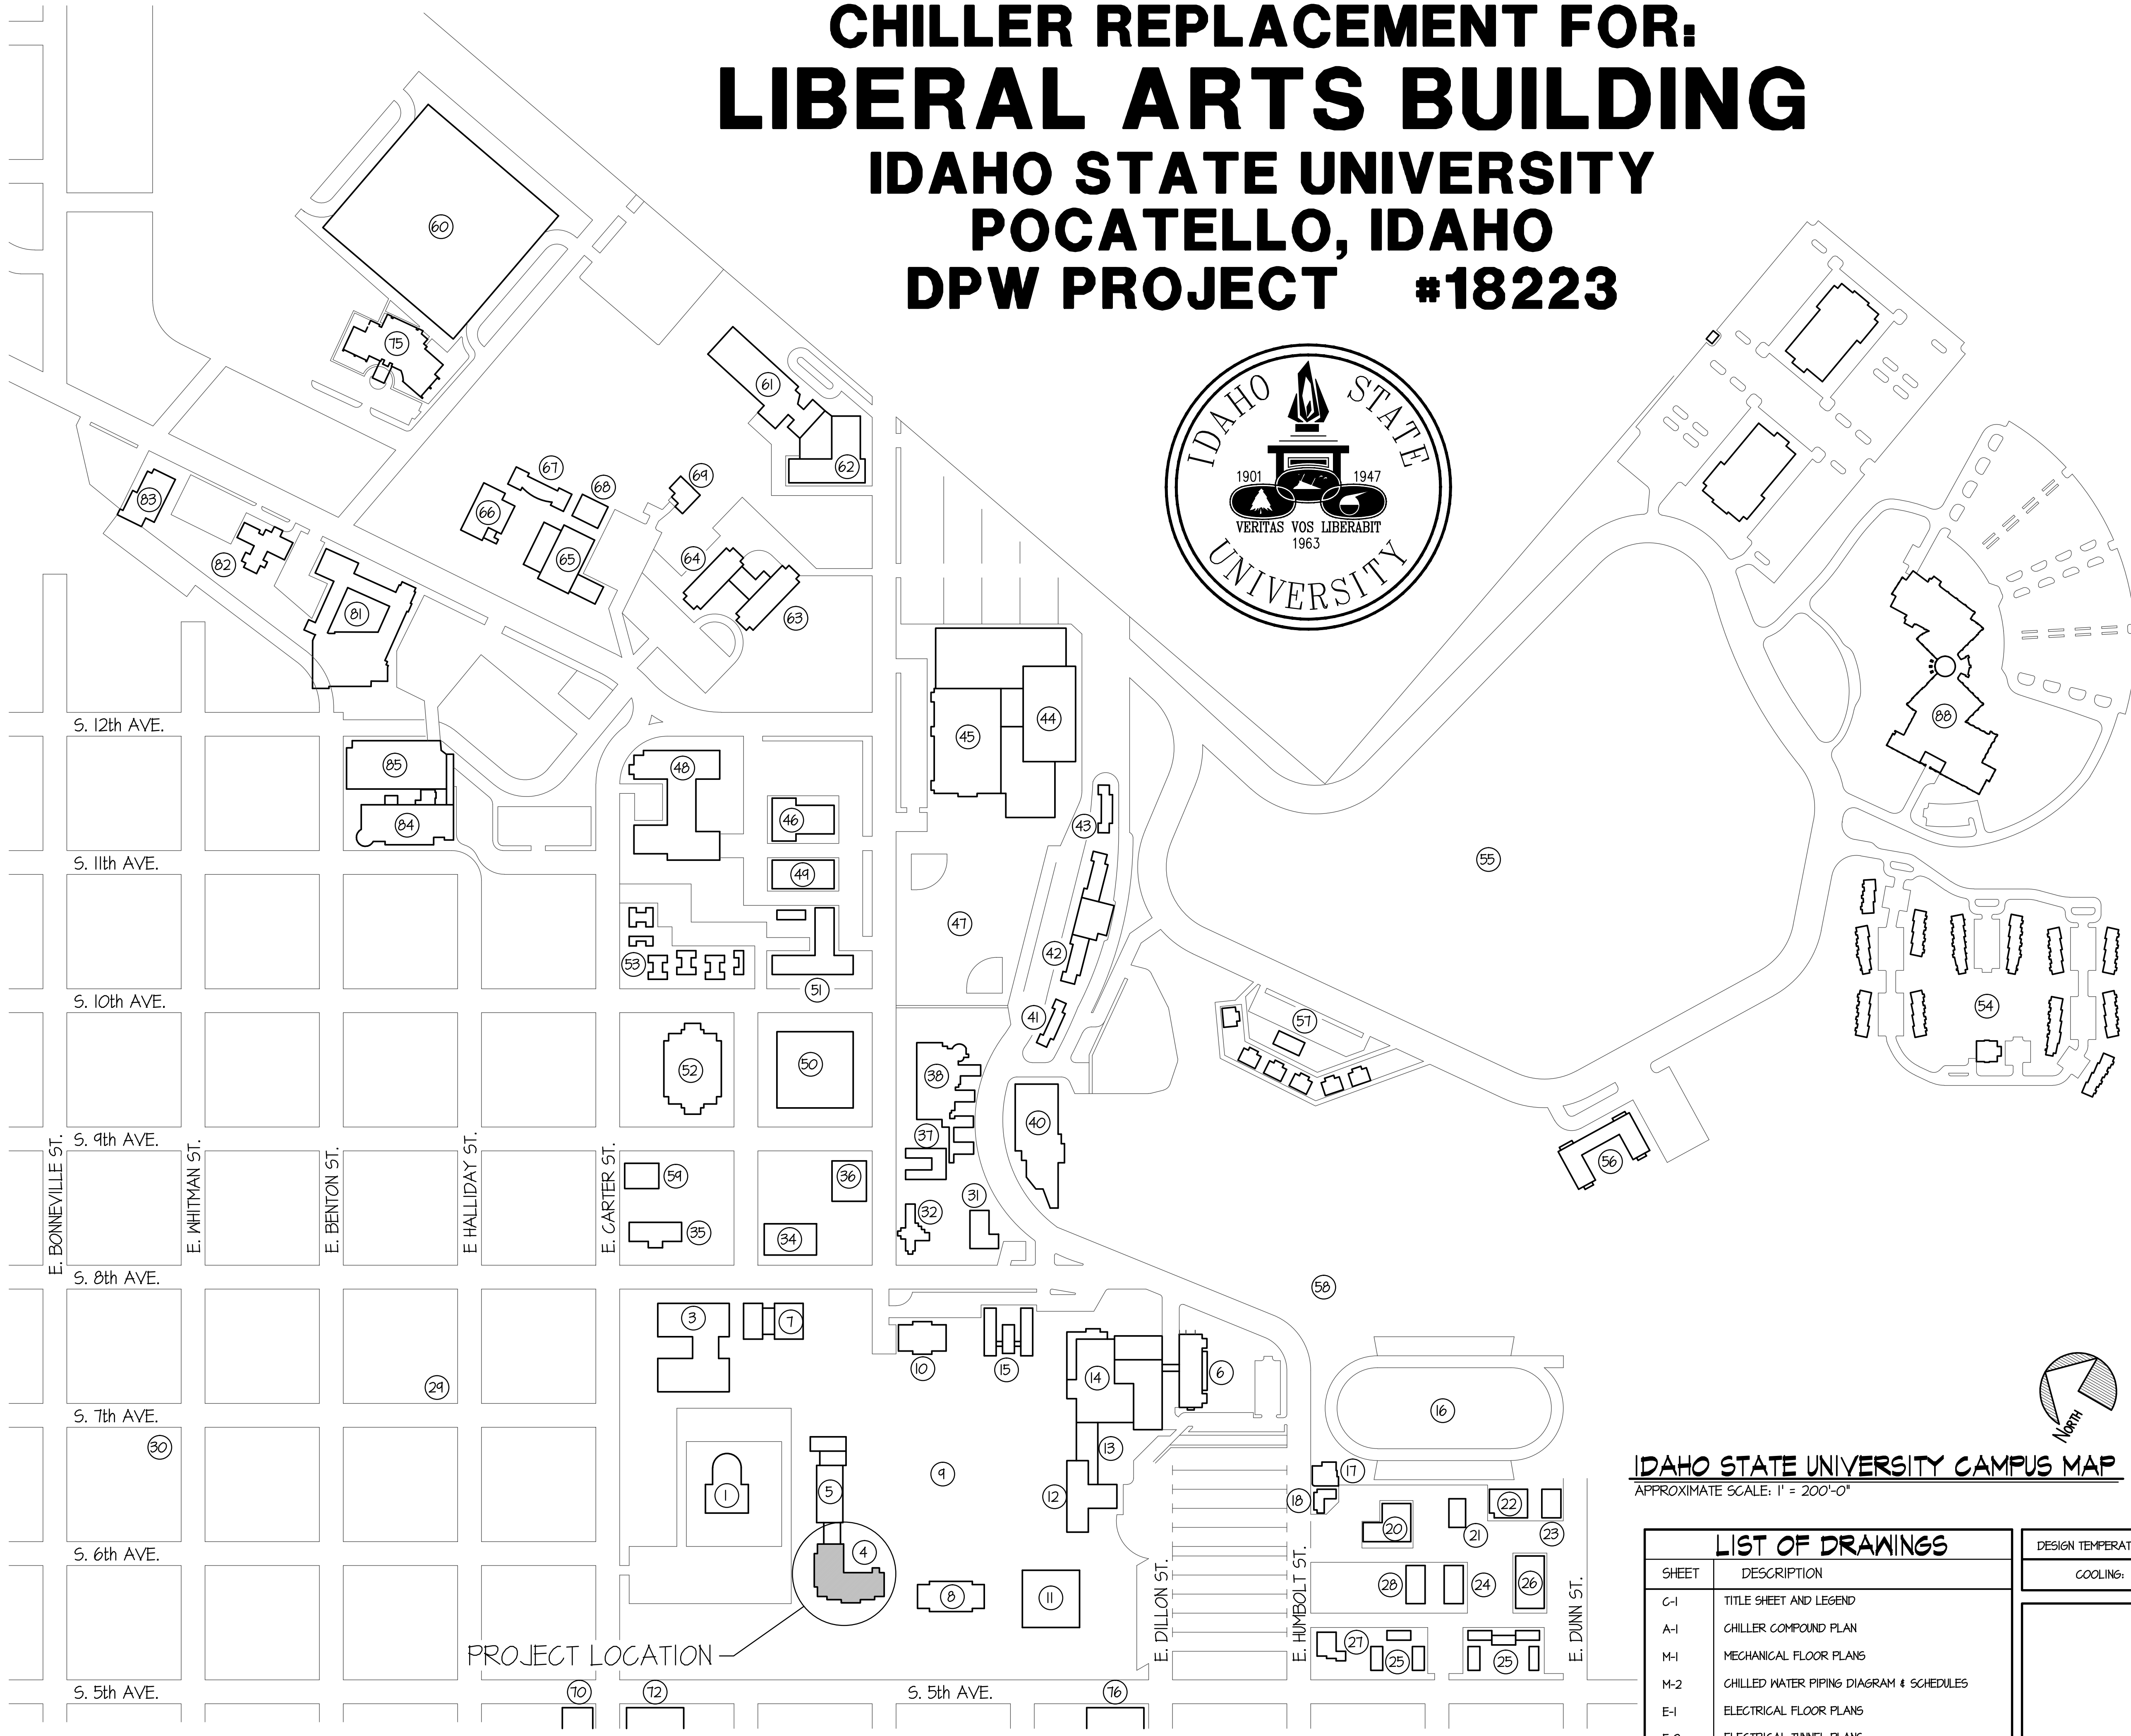

- 1- FRAZIER HALL
- 3- PHYSICAL SCIENCE BLDG.
- 4- KEGEL LIBERAL ARTS BLDG.
- 5- BUSINESS ADMINISTRATION BLDG.
- 6- EARLY LEARNING CENTER & CHILD CARE BDLG.
- 7- LILLIBRIDGE ENGINEERING BLDG.
- 8- LEONARD HALL - COLLEGE OF PHARMACY
- 9- HUTCHISON MEMORIAL QUADRANGLE
- 10- ADMINISTRATION BLDG.
- 11- FINE ARTS BLDG.
- 12- MUSEUM OF NATURAL HISTORY
- 13- HYPOSTYLE
- 14- STUDENT UNION BLDG.
- 15- GRAVELY HALL
- 16- DAVIS FIELD
- 17- DAVIS FIELD HOUSE BLDG
- 18- MAINTENANCE & OPERATIONS
- 20- HEATING PLANT
- 21- TRANSPORTATION SERVICES SHOP
- 22- SHOPS
- 23- WAREHOUSE
- 24- MECHANICAL SHOP BLDG.
- 25- UNIVERSITY COURTS
- 26- SHIPPING & RECEIVING BLDG.
- 27- PUBLIC SAFET BLDG.
- 28- MUSEUM STORAGE BLDG.
- 29- MAGNUSON ALUMNI BLDG.
- 30- PRESIDENT'S RESIDENCE
- 31- STUDENT HEALTH
- 32- DENTAL ARTS BLDG.
- 34- ST. JOHN'S CENTER
- 35- COLONIAL HALL
- 36- UNIVERSITY BIBLE CHURCH
- 37- DENTAL HYGIENE CLINIC
- 38- RENDEZVOUS CENTER
- 40- RED HILL BLDG.
- 41- NICHOLS HALL
- 42- OWEN & REDFIELD COMPLEX
- 43- DYER HALL
- 44- RECREATION FACILITY
- 45- REED GYMNASIUM
- 46- VOCATIONAL ARTS BLDG.
- 47- CADET FIELD
- 48- COLLEGE OF TECHNOLOGY R.F.C. COMPLEX
- 49- INDUSTRIAL CRAFTS BLDG.
- 50- ELI OBOLER LIBRARY
- 51- TRADE & TECHNOLOGY BLDG.
- 52- LDS INSTITUTE OF RELIGION
- 53- PULLING COURTS HOUSING
- 54- RIDGE CREST HOUSING
- 55- BATRZ FIELD
- 56- SCHUBERT HEIGHTS HOUSING
- 57- McINTOSH MANOR HOUSING
- 58- ISU FEDERAL CREDIT UNION
- 58- BUSCO PARK
- 60- HOLT ARENA
- 61- ALBION HALL - CONSUMER ECONOMICS
- 62- EDUCATION BLDG.
- 63- GARRISON HOUSE
- 64- TURNER HOUSE
- 65- GALE LIFE SCIENCE BLDG.
- 66- BECKLEY NURSING BLDG
- 67- LECTURE CENTER
- 68- SPEECH PATHOLOGY
- 69- PLANT SCIENCE BUILDING
- 70- 5th STREET STUDENT HOUSING
- 72- WEST CAMPUS STUDENT HOUSING
- 75- SPORTS MEDICINE BLDG.
- 76- GRADUATE HOUSING
- 81- BANNOCK COUNTY NURSING HOME
- 82- HUMAN DEVELOPMENT CENTER
- 83- DENTAL SCIENCE / FAMILY MEDICINE
- 84- PORTNEUF MEDICAL OFFICE BUILDING
- 85- PORTNEUF PARKING GARAGE
- 88- STEPHENS PERFORMING ARTS CENTER

IDAHO STATE UNIVERSITY CAMPUS MAP
APPROXIMATE SCALE: 1" = 200'-0"

LIST OF DRAWINGS	
SHEET	DESCRIPTION
C-1	TITLE SHEET AND LEGEND
A-1	CHILLER COMPOUND PLAN
M-1	MECHANICAL FLOOR PLANS
M-2	CHILLED WATER PIPING DIAGRAM & SCHEDULES
E-1	ELECTRICAL FLOOR PLANS
E-2	ELECTRICAL TUNNEL PLANS

DESIGN TEMPERATURES	OUTDOOR	INDOOR
	COOLING: 105°F DB / 62°F WB	75°F DB / 64°F WB



Engineered Systems Associates
Mechanical Engineers

Dwayne Sudweeks
1355 East Center - Pocatello, Idaho 83201
Phone: (208) 233-0501 Fax: (208) 233-0529 email: esa@engsystems.com

DPW PROJECT #18223 - CHILLER REPLACEMENT FOR:
LIBERAL ARTS BUILDING
IDAHO STATE UNIVERSITY POCATELLO, IDAHO

TITLE SHEET AND DRAWING INDEX

PROJECT: DPW PROJECT #18223 - CHILLER REPLACEMENT FOR: LIBERAL ARTS BUILDING

SHEET TITLE: TITLE SHEET AND DRAWING INDEX

PROFESSIONAL ENGINEER
Dwayne C. Sudweeks
No. 5762
EXPIRATION DATE 15, 2018
JANUARY C. SUDWECKS

DRWN. BY:	OKD. BY:
M. JENSEN	D. SUDWECKS
JOB NO.	DATE:
17054	FEB. 2018

SHEET: **C-1**
OF: SIX