



HVAC RENOVATIONS FOR:  
LDS MAYWOOD 2ND WARD

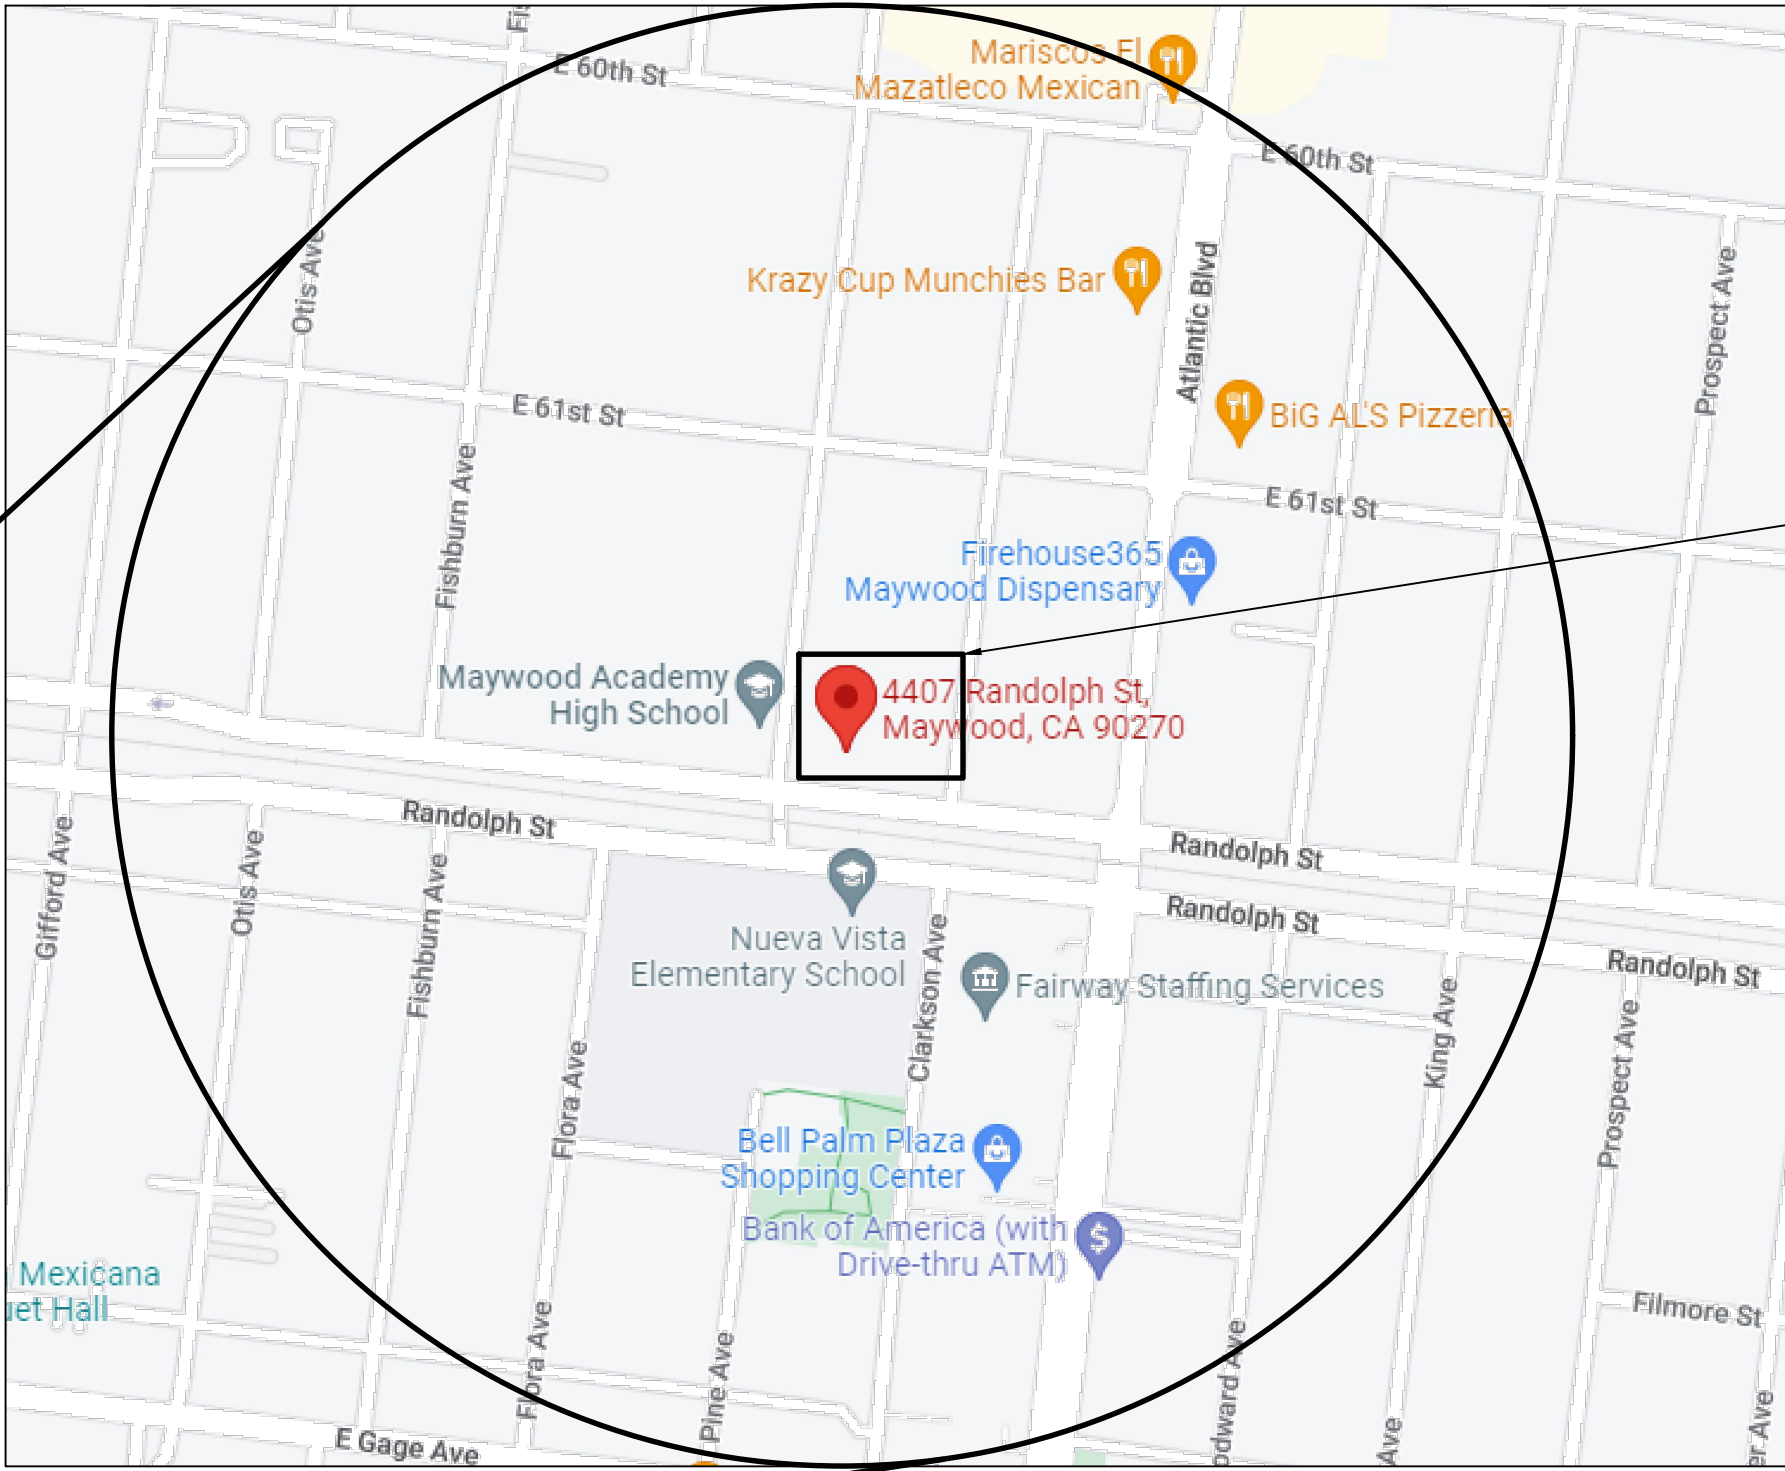


VICINITY MAP  
NO SCALE

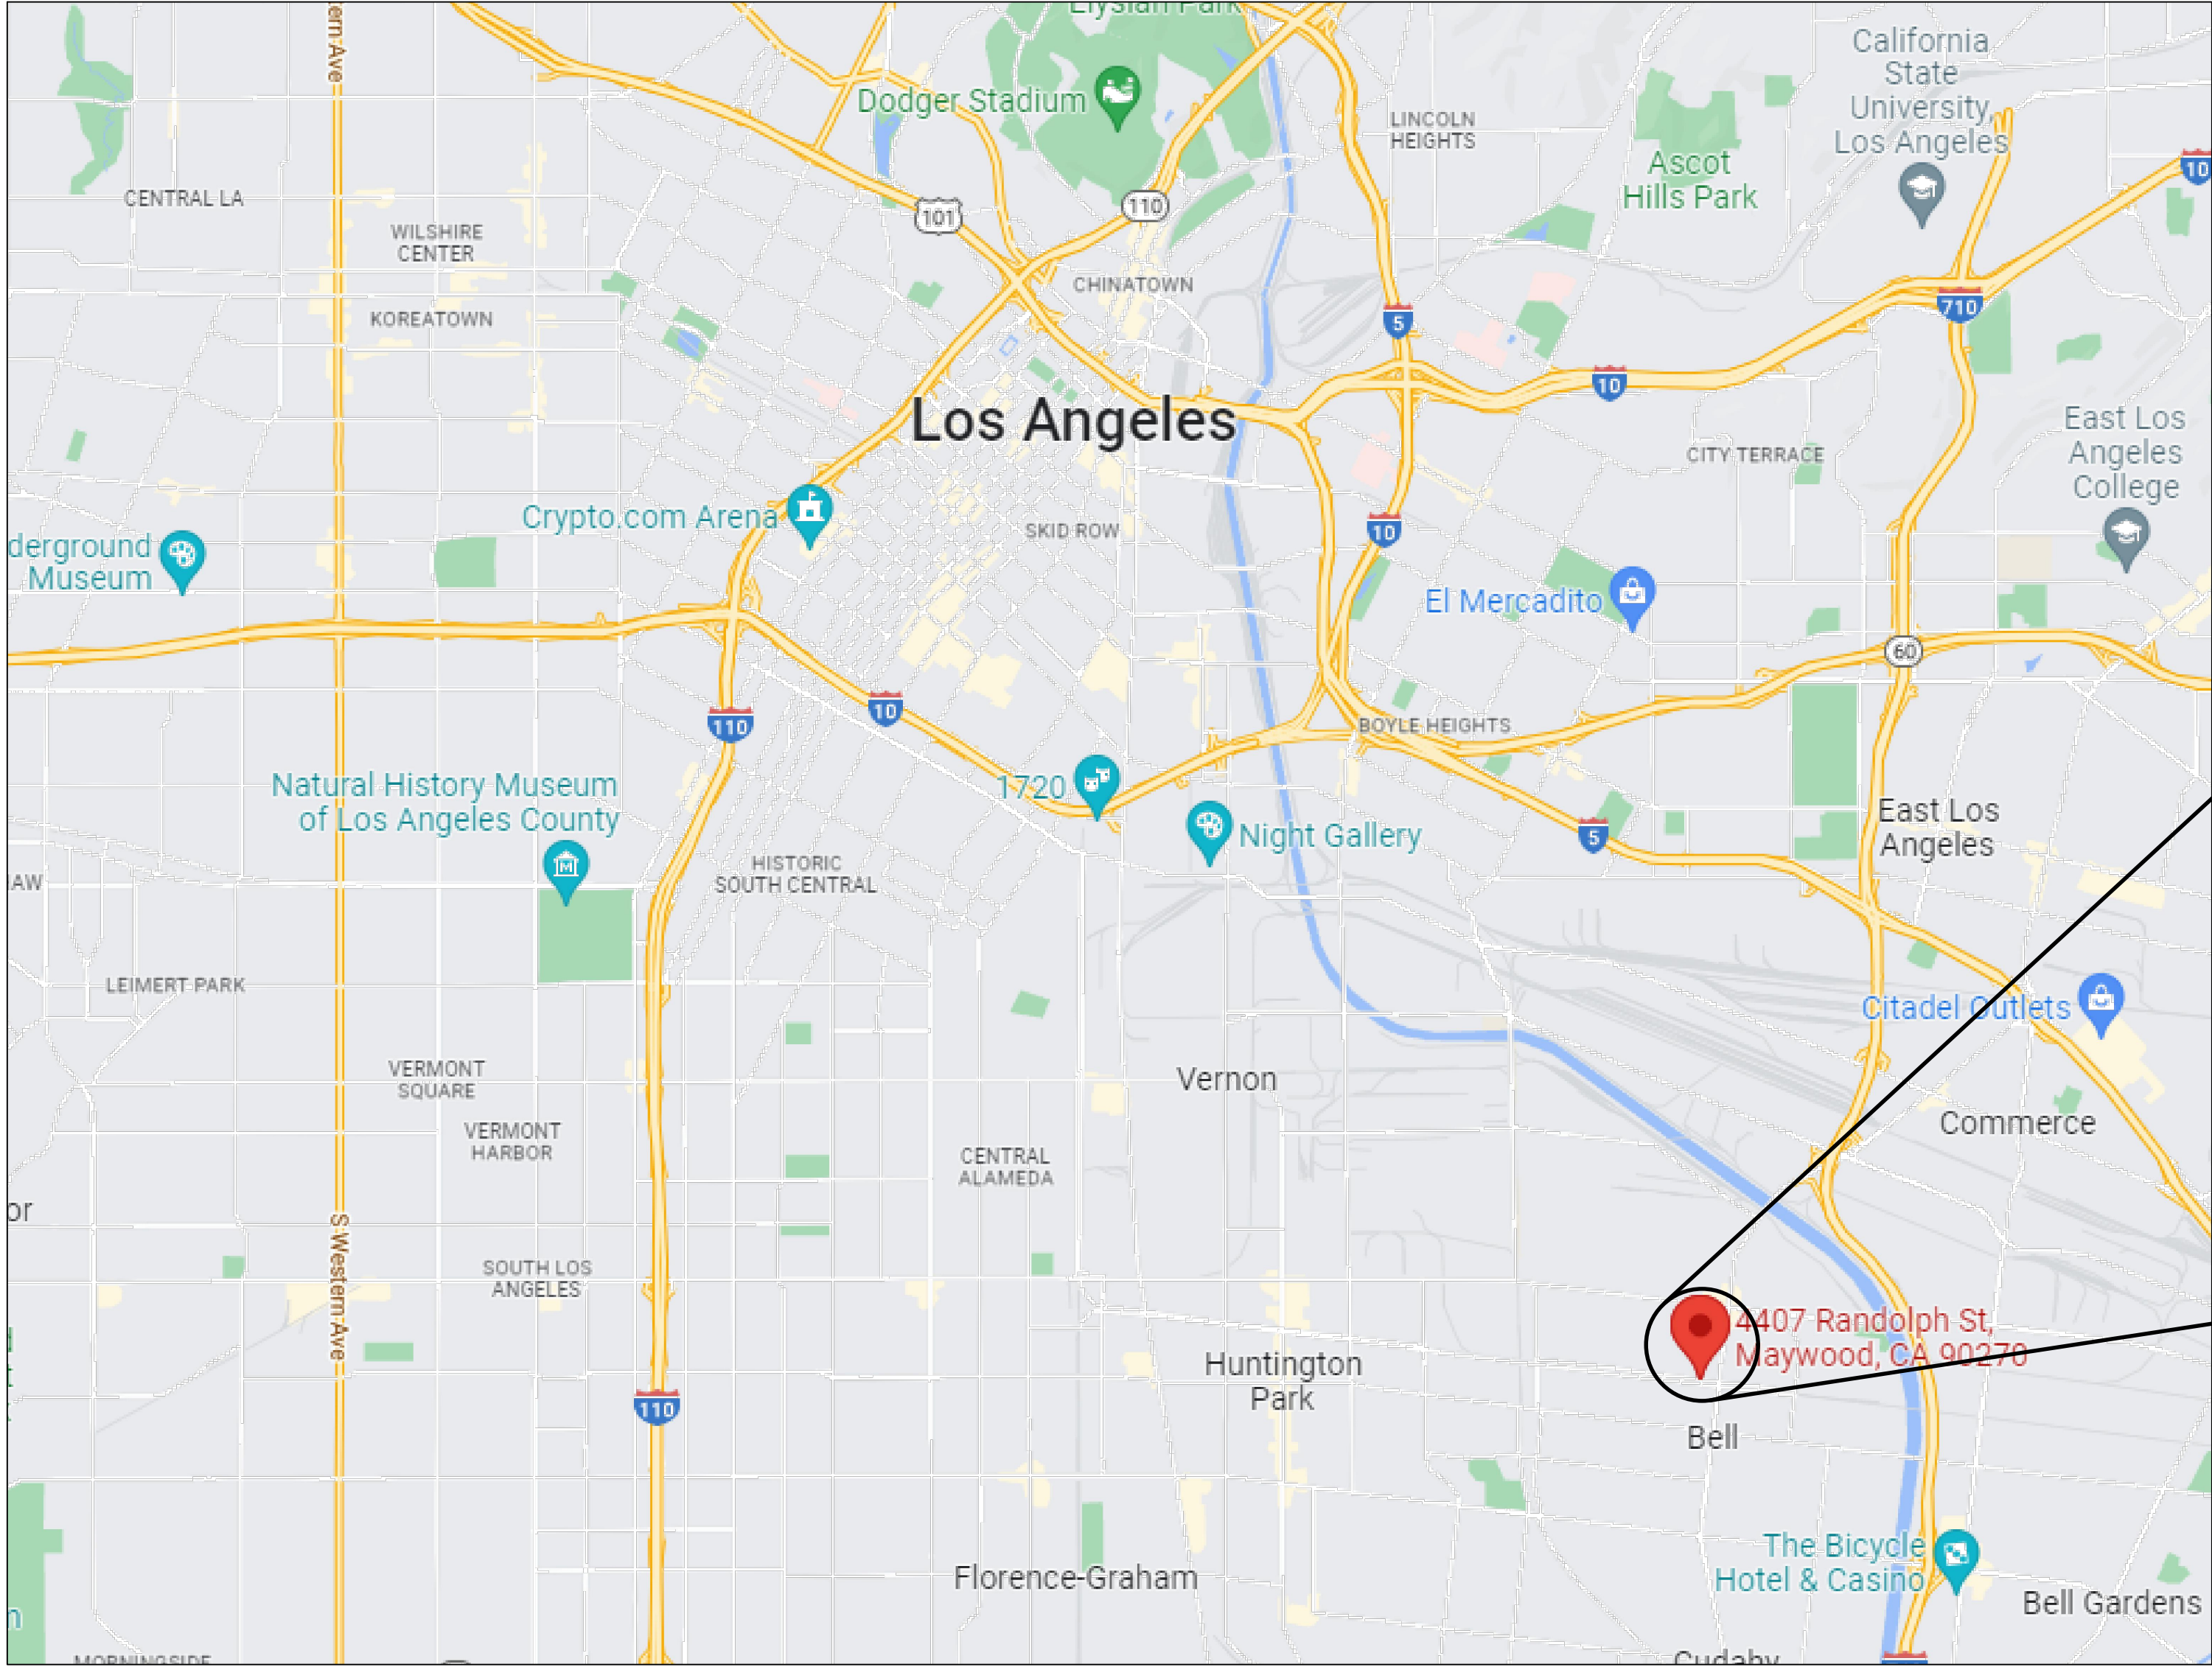

SITE MAP  
NO SCALE



| SHEET INDEX |                                  |
|-------------|----------------------------------|
| S-1         | COVER SHEET AND SHEET INDEX      |
| M-1         | MECHANICAL FLOOR PLANS           |
| M-2         | MECHANICAL DETAILS AND SCHEDULES |

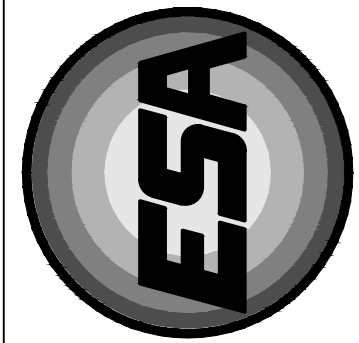


Engineered Systems Associates  
Mechanical Engineers

Dwayne Sudweeks P.E., Dave Hansen P.E., Tanner Davis P.E.  
1355 East Center - Pocatello, Idaho 83201  
Phone: (208) 233-0501 Fax: (208) 233-0529 email: esa@engsystems.com

HVAC RENOVATIONS FOR: PROPERTY # 400-4004  
LDS MAYWOOD 2ND WARD  
4407 RANDOLPH ST. MAYWOOD, CA

PROJECT: SHEET TITLE: COVER SHEET AND SHEET INDEX

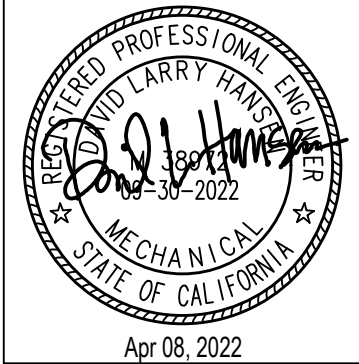

|           |            |
|-----------|------------|
| DRWN. BY: | CKD. BY:   |
| JS        | DH         |
| JOB NO.   | DATE:      |
| 22027     | 04/08/2022 |

SHEET: S-1  
OF: 2